


LAKE TECHNICAL COLLEGE INSTITUTE OF PUBLIC SAFETY

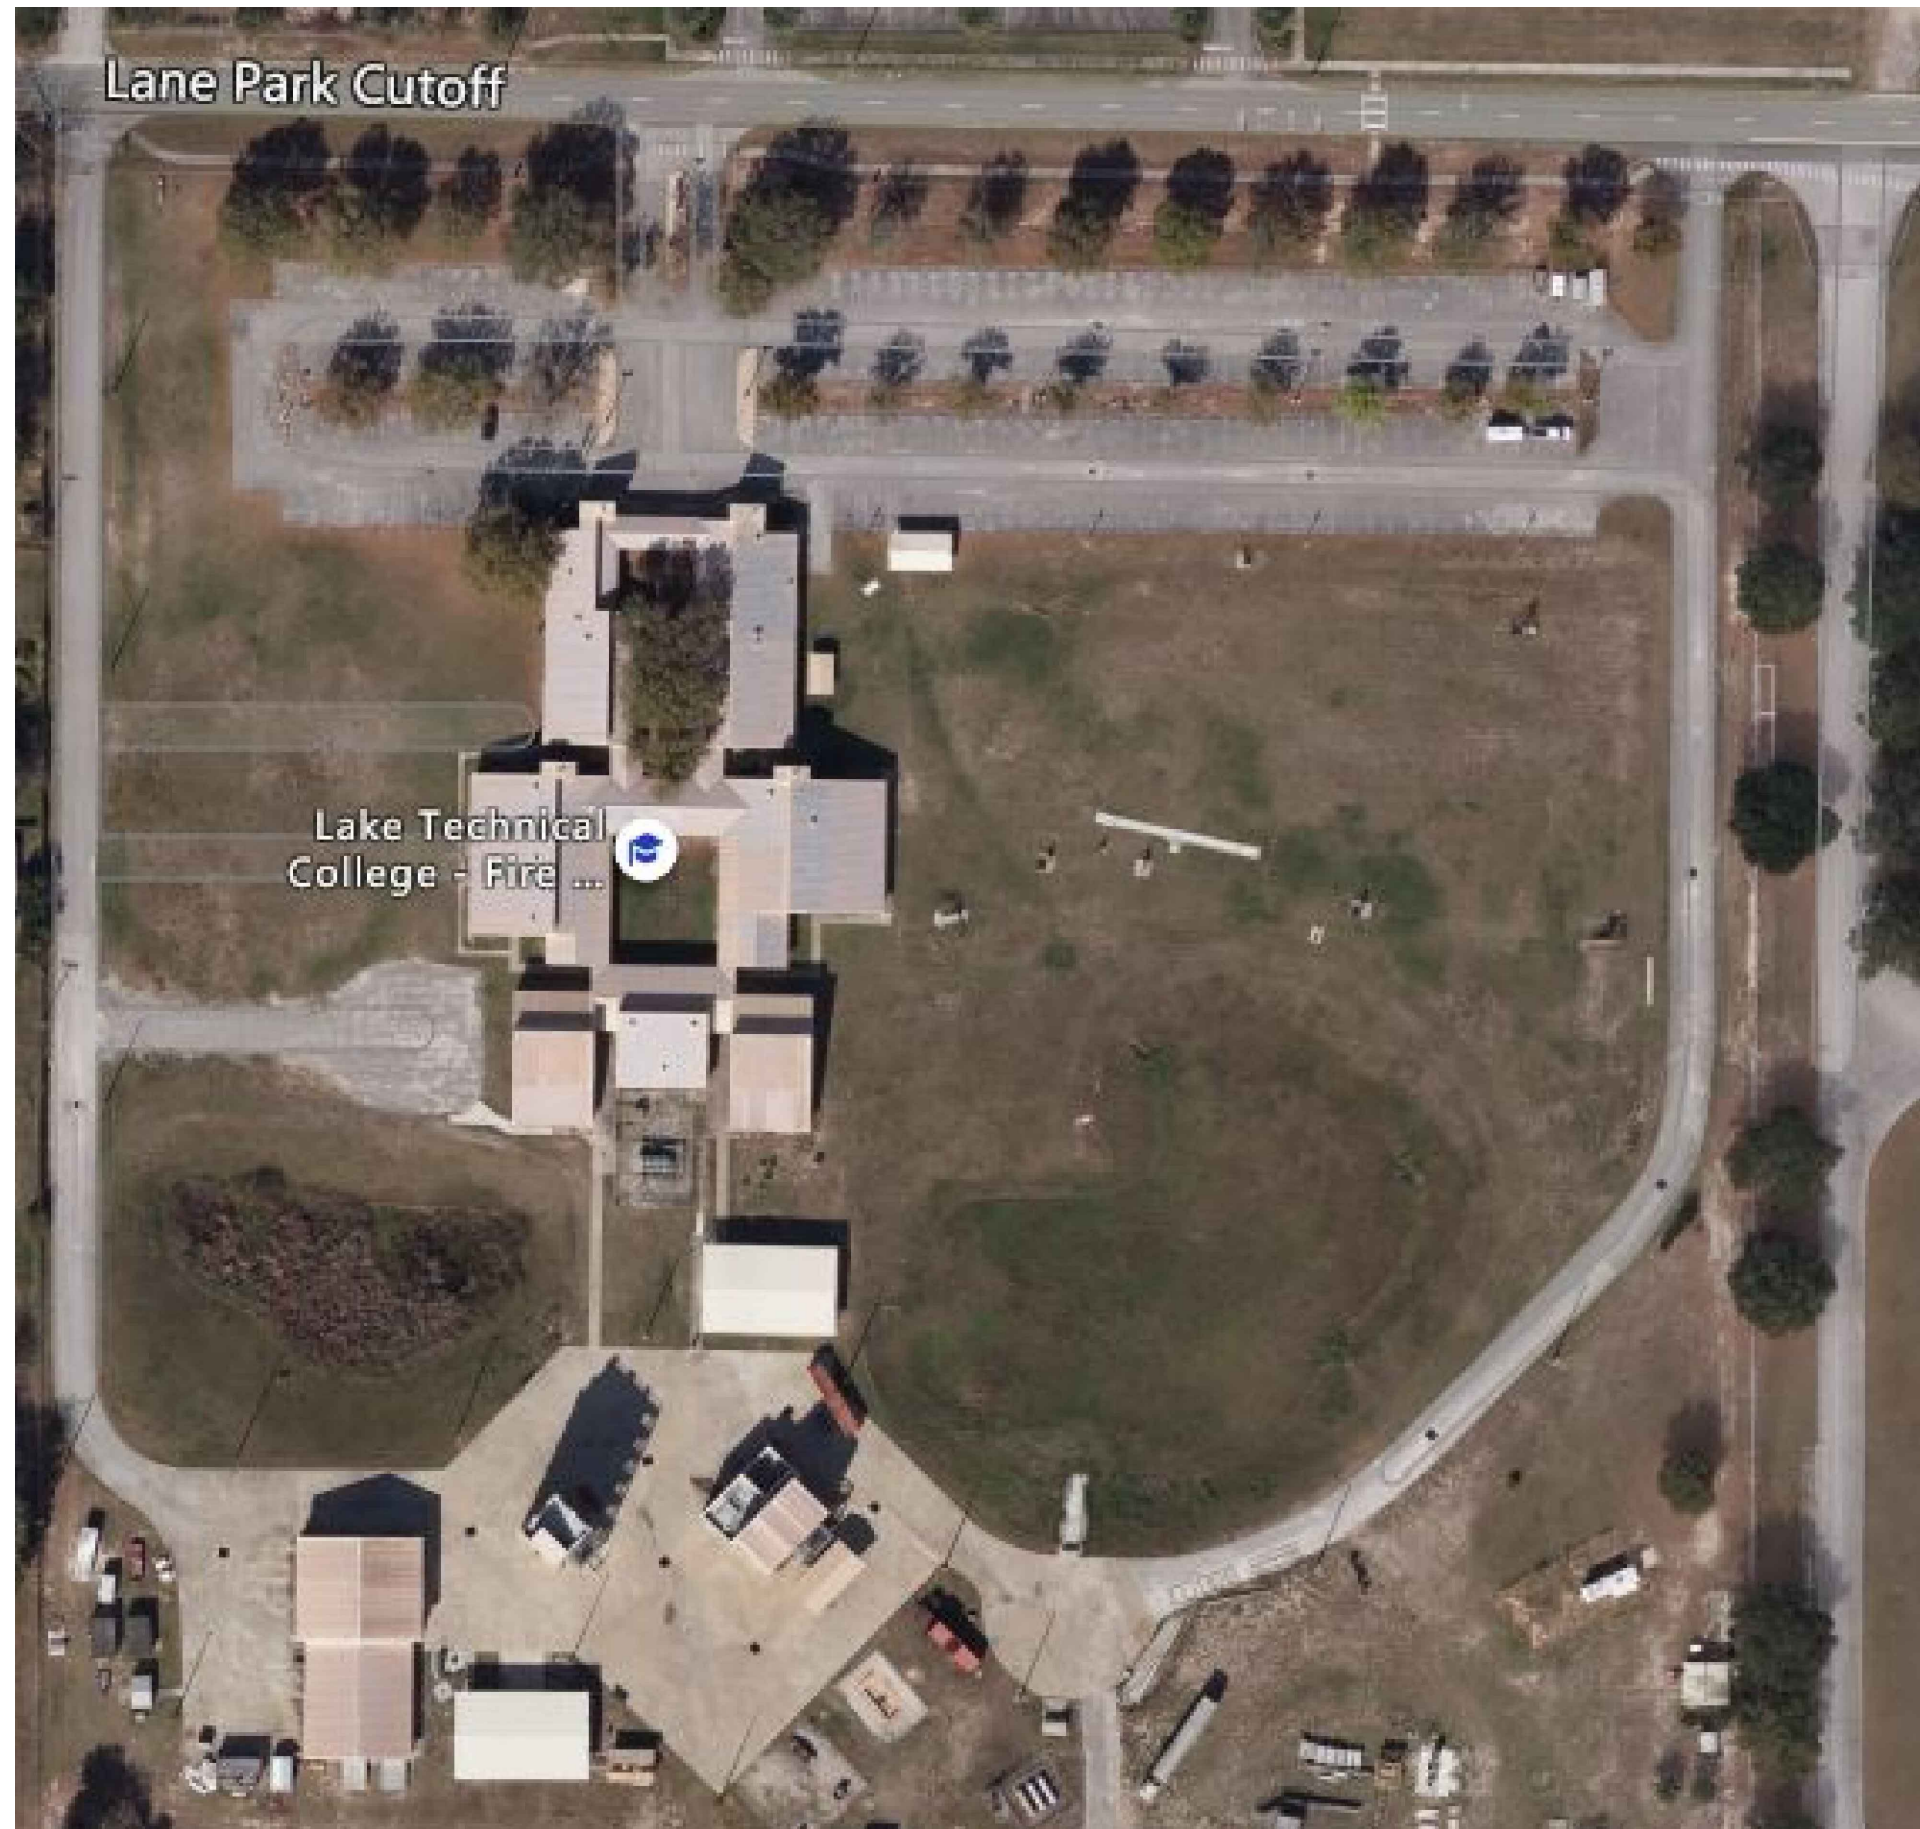

INDEX OF DRAWINGS	
SHT. NO.	DESCRIPTION
SP-01	AERIAL
SP-02	SITE PLAN
B-01	BUILDING 01
B-02	BUILDING 02
B-03	BUILDING 03
B-04	BUILDING 04
B-05	BUILDING 05 & 06
B-06	BUILDING 07
B-07	BUILDING 08 (1ST, 2ND & 3RD)
B-08	BUILDING 09 (1ST, 2ND TO 6TH & ROOF TOP)
B-09	BUILDING 10 & 11

REV	DATE	DESCRIPTION
A	03/01/2021	PRELIMINARY FISH PLAN
B		
0		
1		
2		
3		
4		
5		
6		

ARCHIS PROJECT NO.:	
DRAWN BY: VP	CHECKED BY: SH



158 Terra Mango Loop, Suite B,
Orlando, FL 32835
Main: (407) 293-4168

PREPARED BY:



350 E. Crown Point Road, Suite 1100
Winter Garden, FL 34787
Main: 888.324.2557
Direct: 407.439.1594

DATE

, PE

FL PROFESSIONAL ENGINEER LIC. #

**LAKE TECHNICAL COLLEGE
INSTITUTE OF PUBLIC
SAFETY**

(FISH PLAN)

1565 Lane Park Cutoff Rd,
Tavares, FL

SHEET DESCRIPTION


AERIAL VIEW

SHEET NUMBER

SP-01



1
SP-01 **AERIAL VIEW**
SCALE: N.T.S.

ARCHIS TECHNOLOGIES - \\Server-1\h\Archis\21-043 Lake Tech Brag Center\From ISP\2021-03-25\896_Lake County Fish Survey_Lake Tech Brag Center.dwg March 25, 2021 18:44:25 PC20

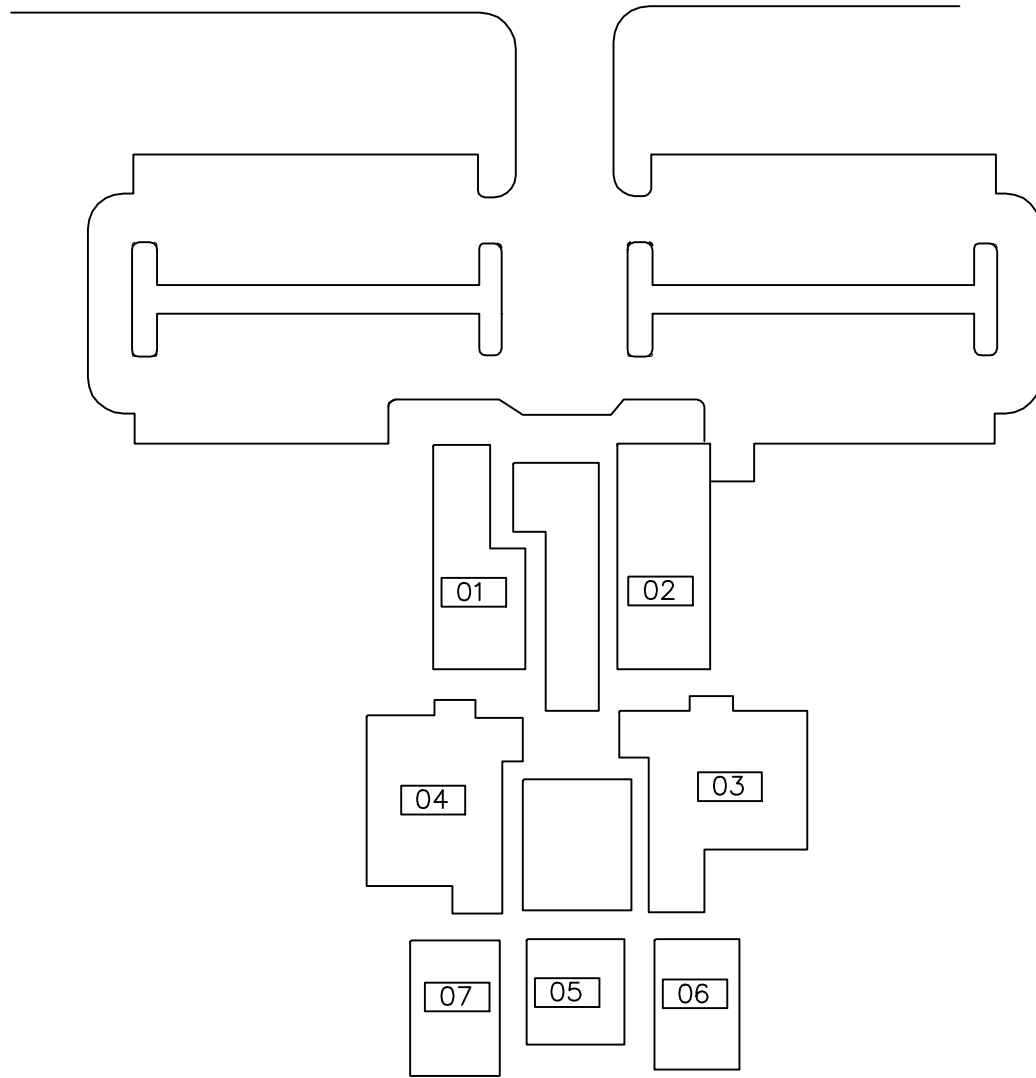

LEGEND

 - 01-ADMINISTRATION
- 02-CAFETERIA
- 03-GUN RANGE
- 04-STORAGE
- 05-LOCKER ROOM
- 06-CLASSROOM
- 07-CLASSROOM
- 08-TRAINING BUILDING
- 09-FIRE TOWER
- 10-CLASSROOM
- 11-FLAMMABLE STORAGE
- 99-PORTABLES

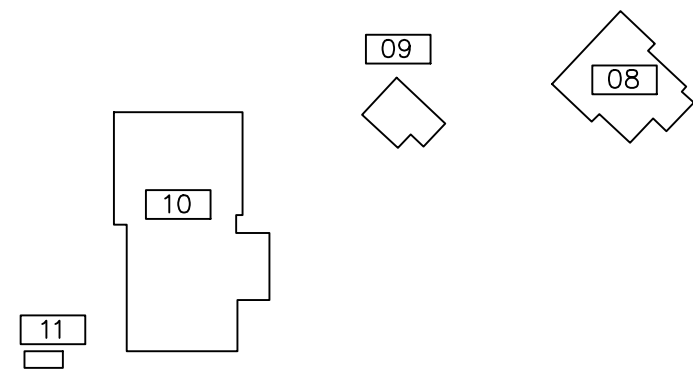

1 **OVERALL SITE PLAN**
 SP-02 SCALE: N.T.S.

REV	DATE	DESCRIPTION
A	03/01/2021	PRELIMINARY FISH PLAN
B		
0		
1		
2		
3		
4		
5		
6		

ARCHIS PROJECT NO.:

DRAWN BY:	CHECKED BY:
VP	SH



CMI
 158 Terra Mango Loop, Suite B,
 Orlando, FL 32835
 Main: (407) 293-4168

PREPARED BY:

350 E. Crown Point Road, Suite 1100
 Winter Garden, FL 34787
 Main: 888.324.2557
 Direct: 407.439.1594



DATE
 , PE
 FL PROFESSIONAL ENGINEER LIC. #

**LAKE TECHNICAL COLLEGE
 INSTITUTE OF PUBLIC
 SAFETY
 (FISH PLAN)**
 1565 Lane Park Cutoff Rd,
 Tavares, FL

SHEET DESCRIPTION
**OVERALL SITE
 PLAN**

SHEET NUMBER
SP-02


ARCHIS TECHNOLOGIES - \\Server-1\h\Archis\21-043 Lake Tech Brag Center.dwg March 25, 2021 18:44:33 PC20

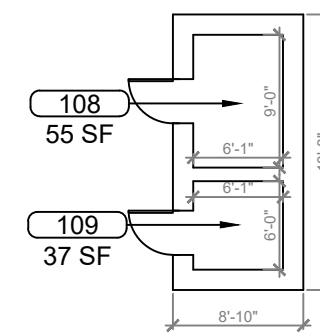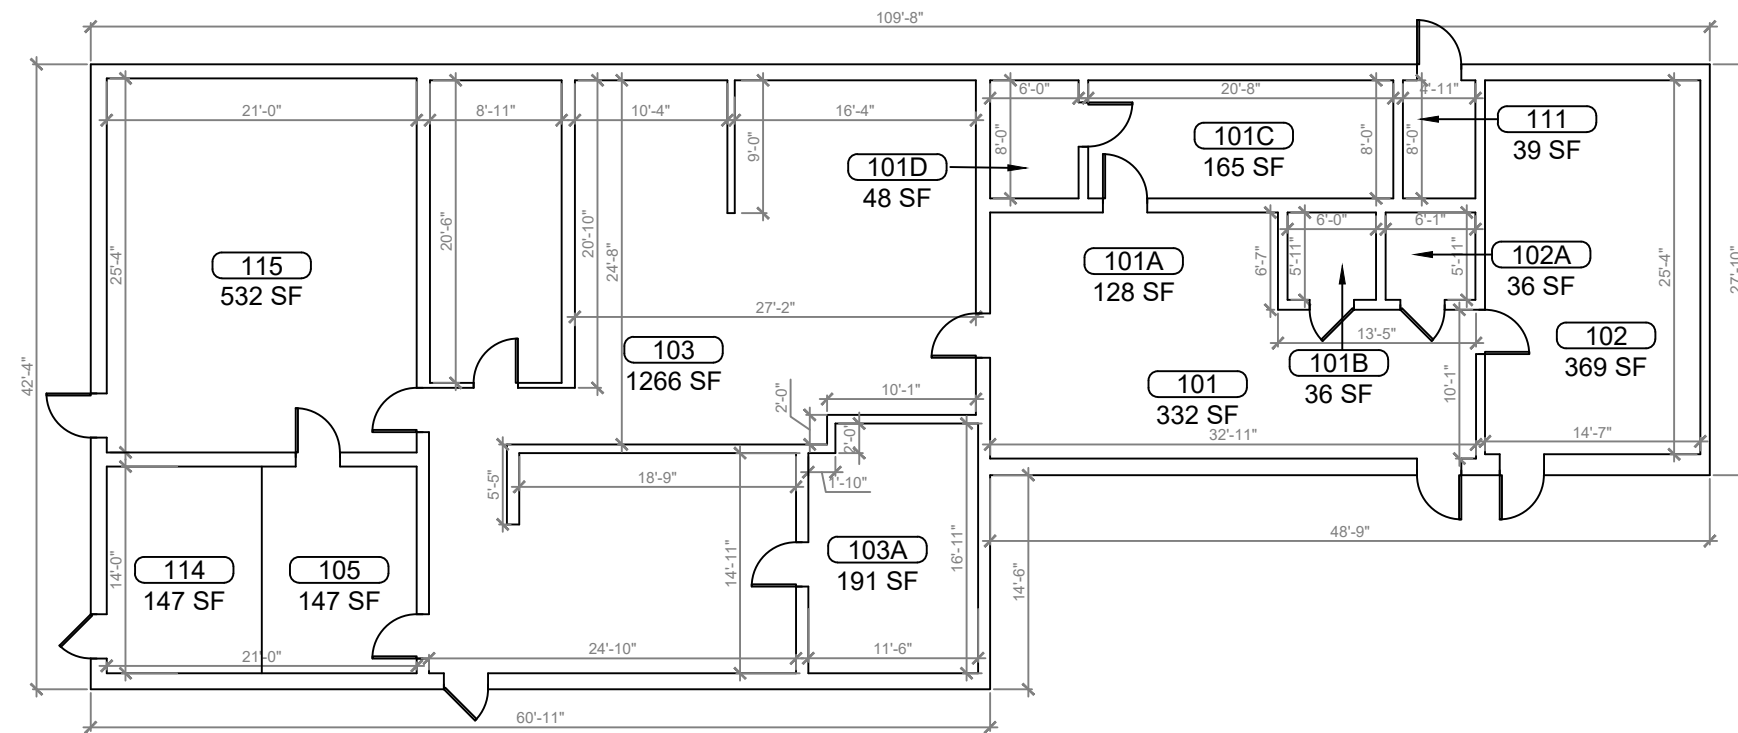

BUILDING 01 FLOOR PLAN
 SCALE: 3/16"=1'-0"

REV	DATE	DESCRIPTION
A	03/01/2021	PRELIMINARY FISH PLAN
B		
0		
1		
2		
3		
4		
5		
6		

ARCHIS PROJECT NO.:	
DRAWN BY:	CHECKED BY:
VP	SH

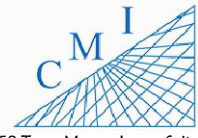

158 Terra Mango Loop, Suite B,
 Orlando, FL 32835
 Main: (407) 293-4168

PREPARED BY:
ARCHIS
 350 E. Crown Point Road, Suite 1100
 Winter Garden, FL 34787
 Main: 888.324.2557
 Direct: 407.439.1594

DATE
 , PE
 FL PROFESSIONAL ENGINEER LIC. #



**LAKE TECHNICAL COLLEGE
 INSTITUTE OF PUBLIC
 SAFETY
 (FISH PLAN)**
 1565 Lane Park Cutoff Rd,
 Tavares, FL

SHEET DESCRIPTION
BUILDING 01

SHEET NUMBER
B-01

KEY PLAN


ARCHIS TECHNOLOGIES - \\Server-1\h\Archis\21-043 Lake Tech Brag Center.dwg March 25, 2021 18:44:38 PC20

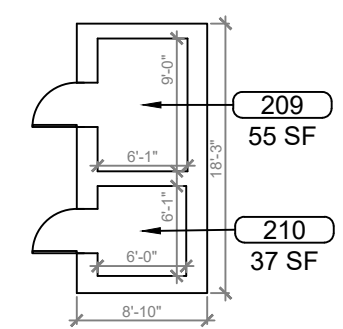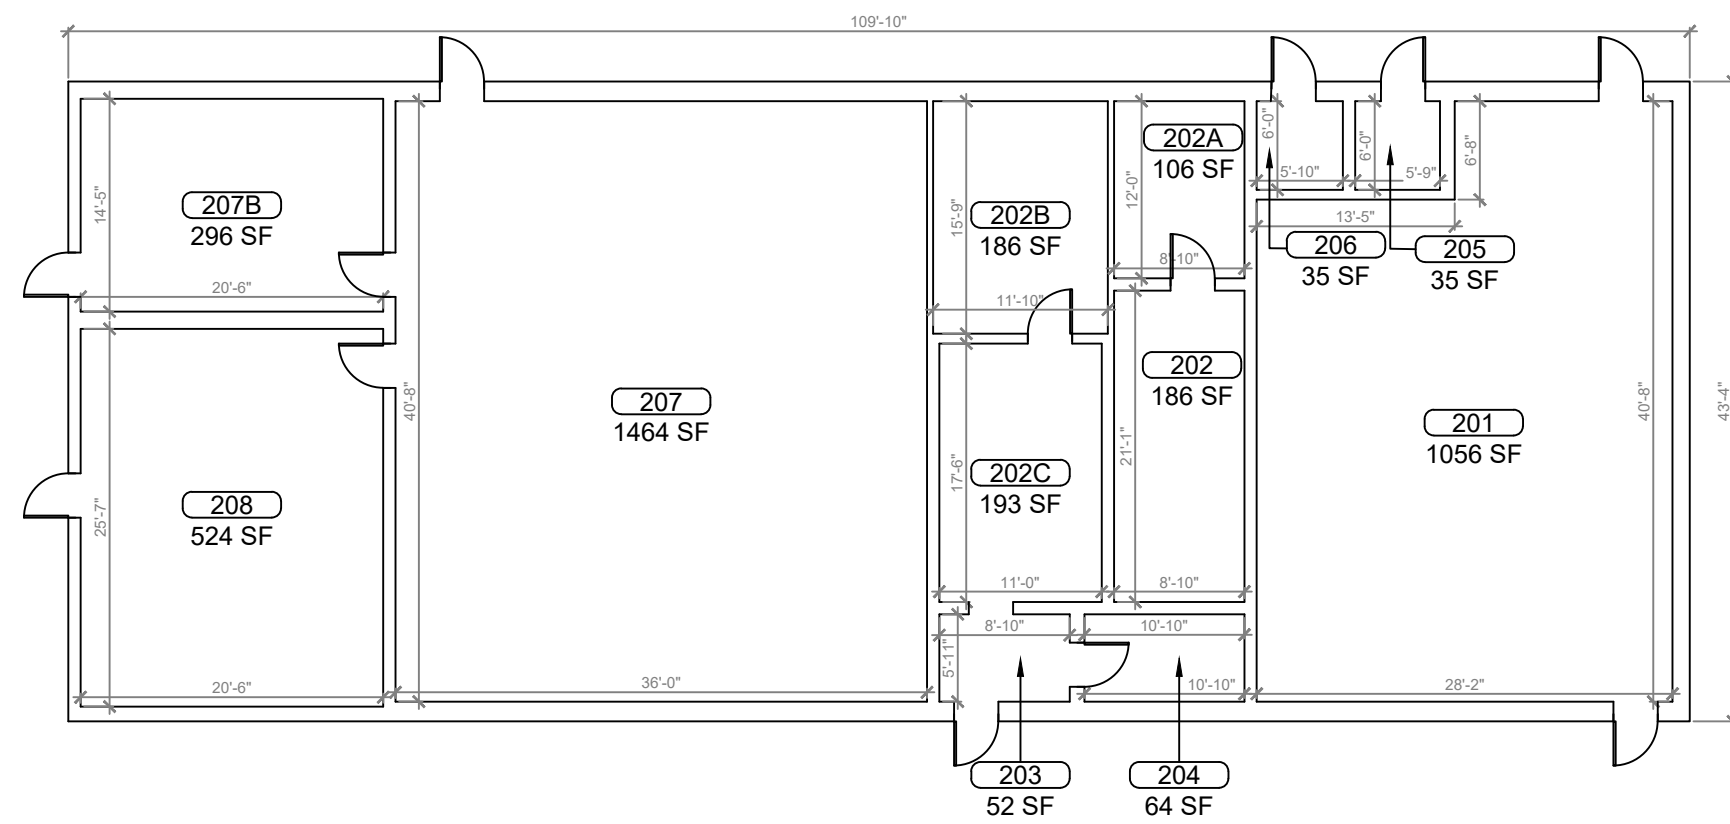

1
B-02 **BUILDING 02 FLOOR PLAN**
SCALE: 3/16"=1'-0"

REV	DATE	DESCRIPTION
A	03/01/2021	PRELIMINARY FISH PLAN
B		
0		
1		
2		
3		
4		
5		
6		

ARCHIS PROJECT NO.:	
DRAWN BY: VP	CHECKED BY: SH

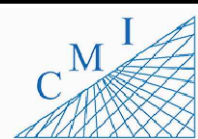

158 Terra Mango Loop, Suite B,
Orlando, FL 32835
Main: (407) 293-4168


PREPARED BY:
ARCHIS
350 E. Crown Point Road, Suite 1100
Winter Garden, FL 34787
Main: 888.324.2557
Direct: 407.439.1594

DATE
_____, PE
FL PROFESSIONAL ENGINEER LIC. #


**LAKE TECHNICAL COLLEGE
INSTITUTE OF PUBLIC
SAFETY
(FISH PLAN)**
1565 Lane Park Cutoff Rd,
Tavares, FL

SHEET DESCRIPTION
BUILDING 02

SHEET NUMBER
B-02

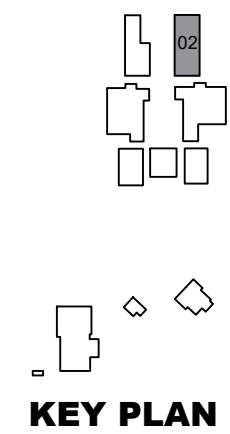

ARCHIS TECHNOLOGIES - \\Server-1\h\Archis\21-043 Lake Tech Brag Center\From ISP\2021-03-25\896_Lake County Fish Survey_Lake Tech Brag Center.dwg March 25, 2021 18:44:43 PC20

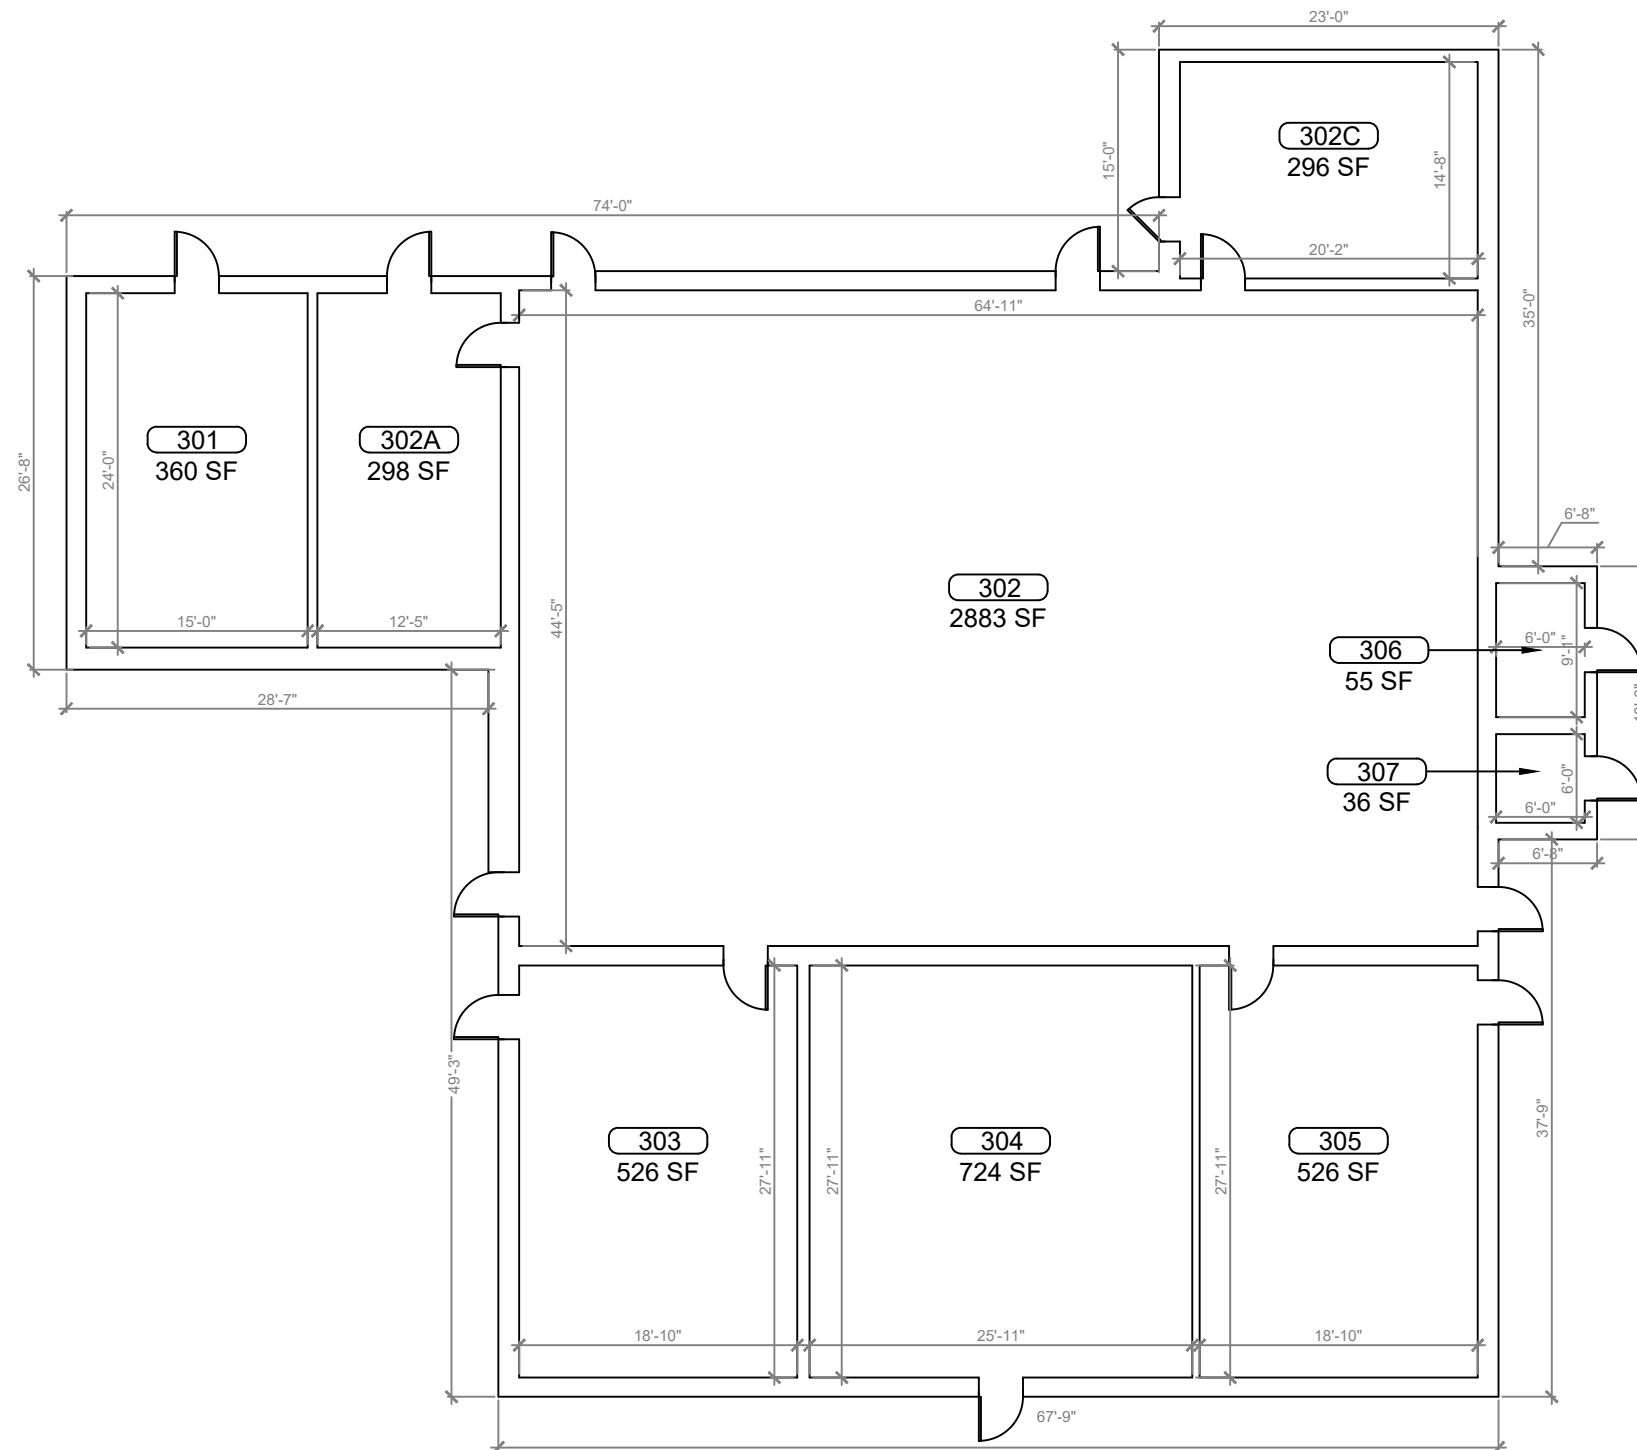

REV	DATE	DESCRIPTION
A	03/01/2021	PRELIMINARY FISH PLAN
B		
0		
1		
2		
3		
4		
5		
6		

ARCHIS PROJECT NO.:	
DRAWN BY:	CHECKED BY:
VP	SH



CMI
 158 Terra Mango Loop, Suite B,
 Orlando, FL 32835
 Main: (407) 293-4168

PREPARED BY:

 350 E. Crown Point Road, Suite 1100
 Winter Garden, FL 34787
 Main: 888.324.2557
 Direct: 407.439.1594


DATE _____
 _____, PE
 FL PROFESSIONAL ENGINEER LIC. # _____

**LAKE TECHNICAL COLLEGE
 INSTITUTE OF PUBLIC
 SAFETY
 (FISH PLAN)**
 1565 Lane Park Cutoff Rd,
 Tavares, FL


SHEET DESCRIPTION
BUILDING 03

SHEET NUMBER
B-03

1 BUILDING 03 FLOOR PLAN
 B-03 SCALE: 3/16"=1'-0"

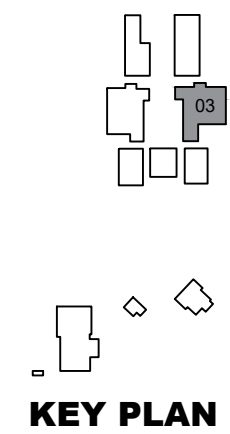

ARCHIS TECHNOLOGIES - \\Server-1\h\Archis\21-043 Lake Tech Brag Center.dwg Tech Brag Center.dwg March 25, 2021 18:44:48 PC20

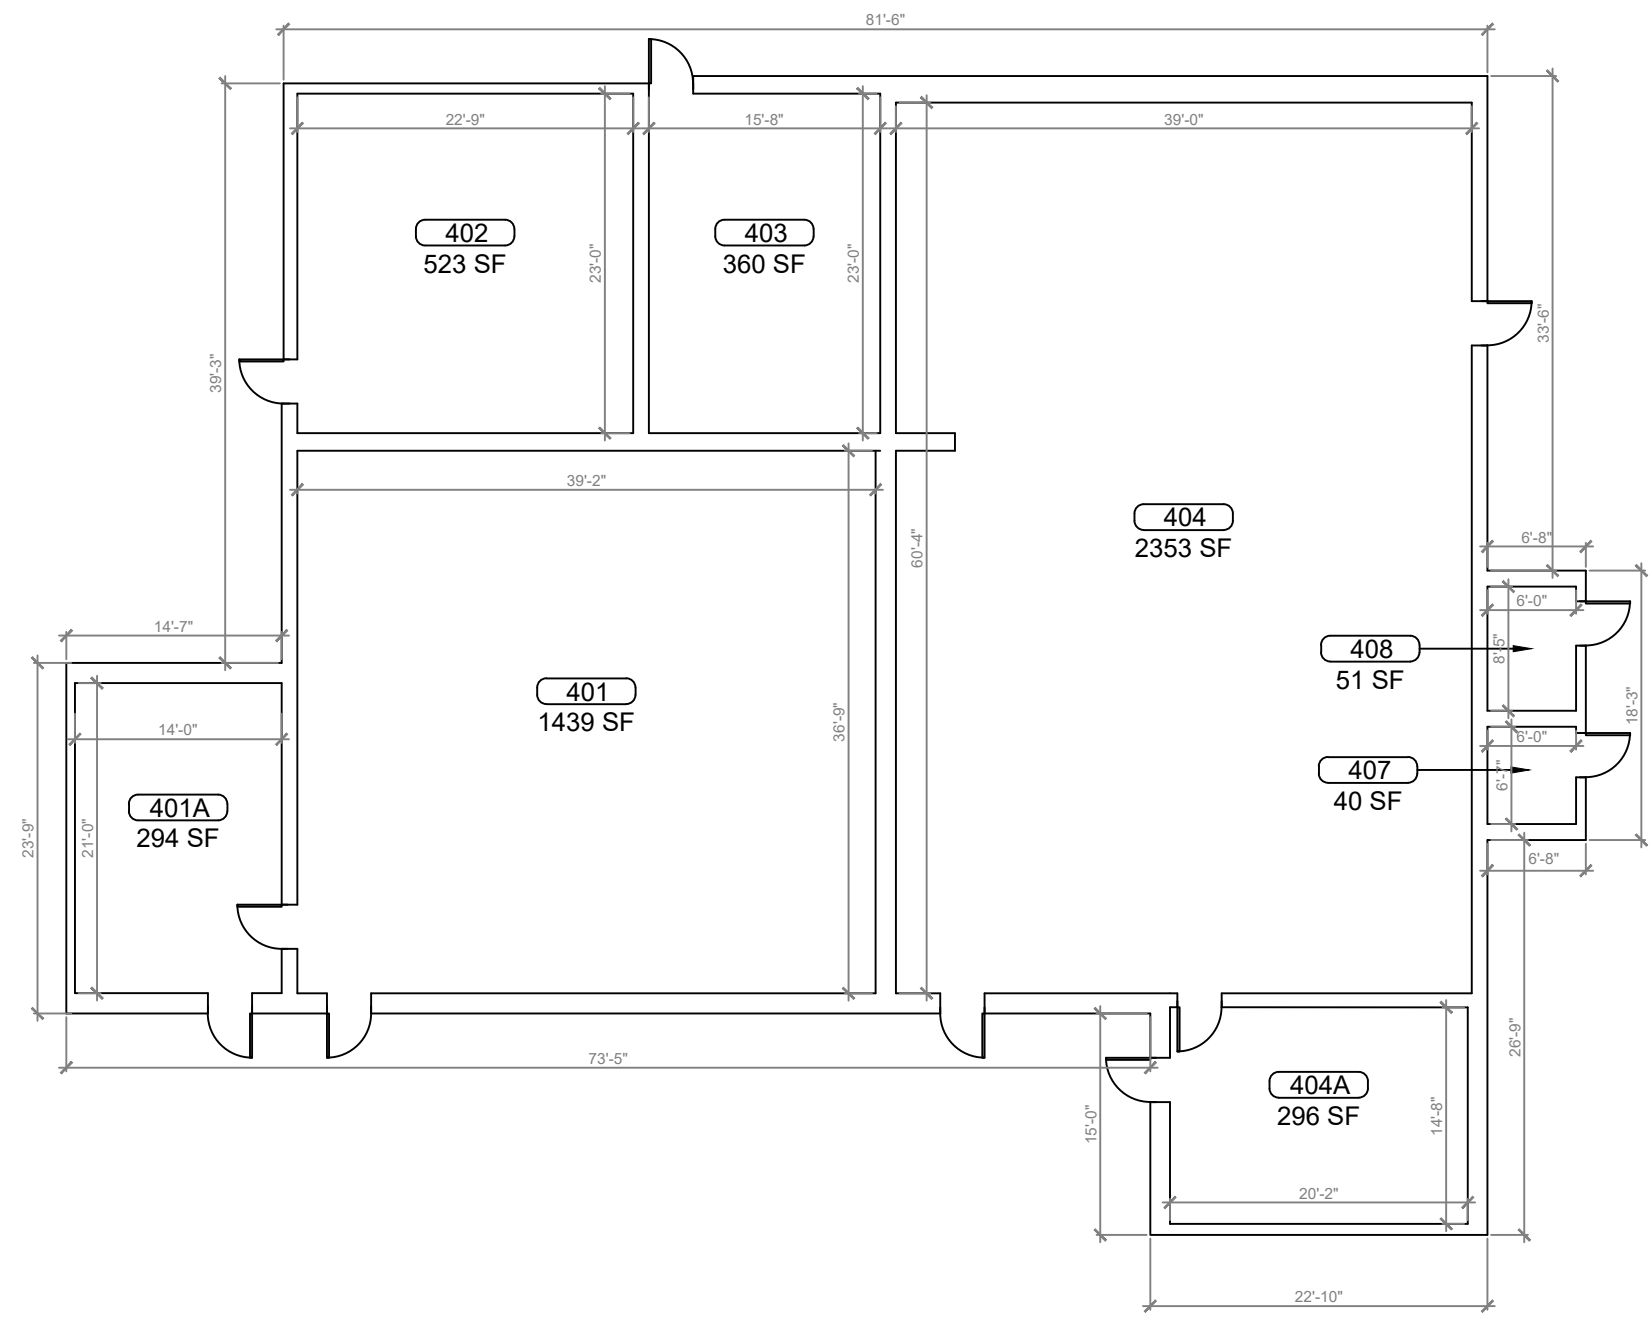

REV	DATE	DESCRIPTION
A	03/01/2021	PRELIMINARY FISH PLAN
B		
0		
1		
2		
3		
4		
5		
6		

ARCHIS PROJECT NO.:

DRAWN BY:	CHECKED BY:
VP	SH



158 Terra Mango Loop, Suite B,
Orlando, FL 32835
Main: (407) 293-4168

PREPARED BY:



350 E. Crown Point Road, Suite 1100
Winter Garden, FL 34787
Main: 888.324.2557
Direct: 407.439.1594

DATE

, PE

FL PROFESSIONAL ENGINEER LIC. #

**LAKE TECHNICAL COLLEGE
INSTITUTE OF PUBLIC
SAFETY
(FISH PLAN)**
1565 Lane Park Cutoff Rd,
Tavares, FL


SHEET DESCRIPTION

BUILDING 04


SHEET NUMBER

B-04


1 BUILDING 04 FLOOR PLAN
B-04 SCALE: 3/16"=1'-0"

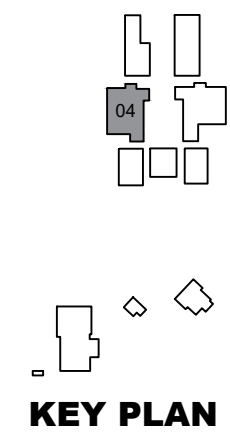


ARCHIS TECHNOLOGIES - \\Server-1\h\Archis\21-043 Lake Tech Brag Center.dwg March 25, 2021 18:44:53 PC20

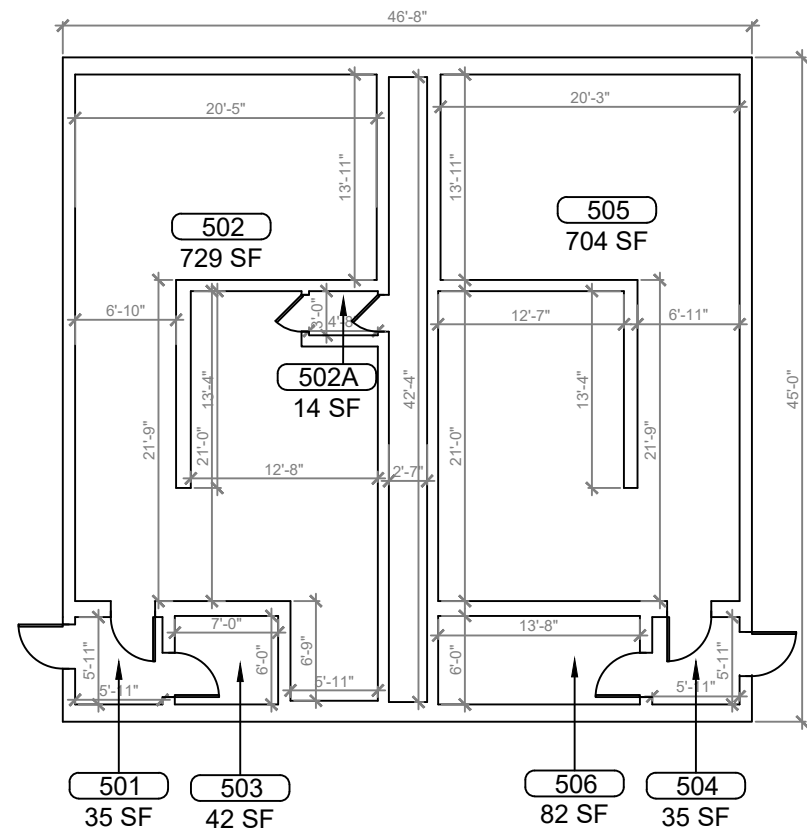

1
B-05 **BUILDING 05 FLOOR PLAN**
SCALE: 3/16"=1'-0"

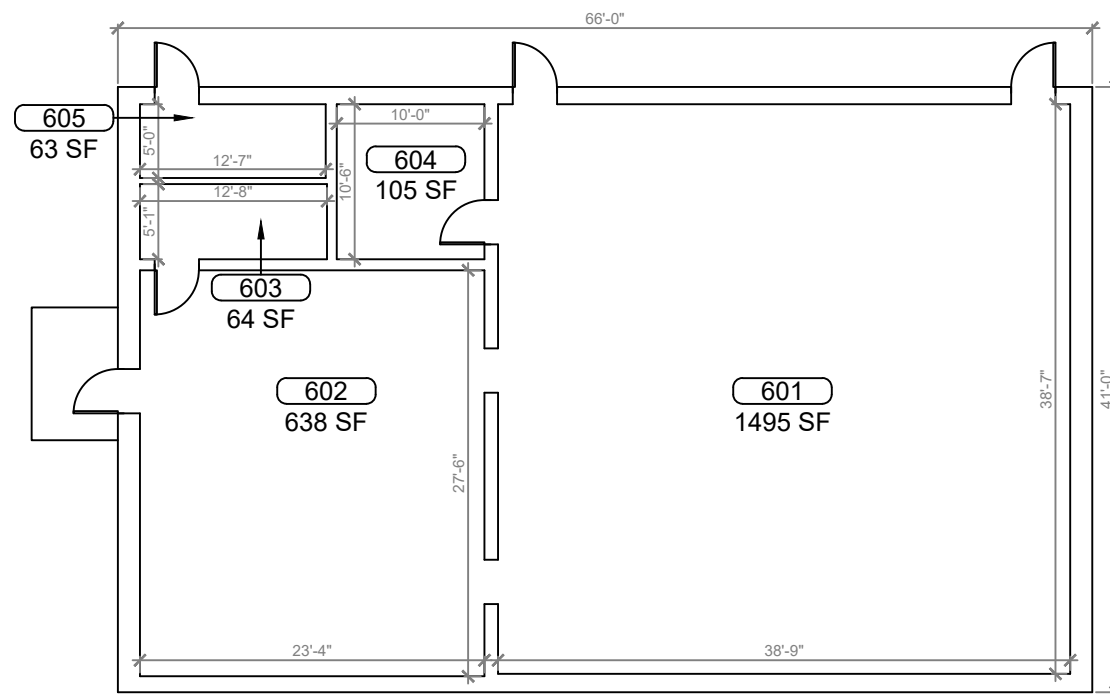


2
B-05 **BUILDING 06 FLOOR PLAN**
SCALE: 3/16"=1'-0"

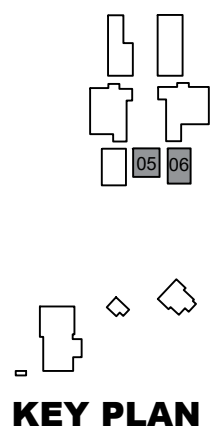

REV	DATE	DESCRIPTION
A	03/01/2021	PRELIMINARY FISH PLAN
B		
0		
1		
2		
3		
4		
5		
6		

ARCHIS PROJECT NO.:

DRAWN BY:	CHECKED BY:
VP	SH

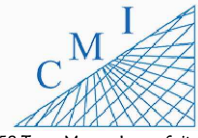

158 Terra Mango Loop, Suite B,
Orlando, FL 32835
Main: (407) 293-4168

PREPARED BY:

ARCHIS

350 E. Crown Point Road, Suite 1100
Winter Garden, FL 34787
Main: 888.324.2557
Direct: 407.439.1594

DATE
, PE
FL PROFESSIONAL ENGINEER LIC. #


**LAKE TECHNICAL COLLEGE
INSTITUTE OF PUBLIC
SAFETY
(FISH PLAN)**

1565 Lane Park Cutoff Rd,
Tavares, FL


SHEET DESCRIPTION
**BUILDING 05 &
06**

SHEET NUMBER
B-05

ARCHIS TECHNOLOGIES - \\Server-1\h\Archis\21-043 Lake Tech Brag Center\21-043 Lake Tech Brag Center\Fish Survey_Lake Tech Brag Center.dwg March 25, 2021 18:44:58 PC20

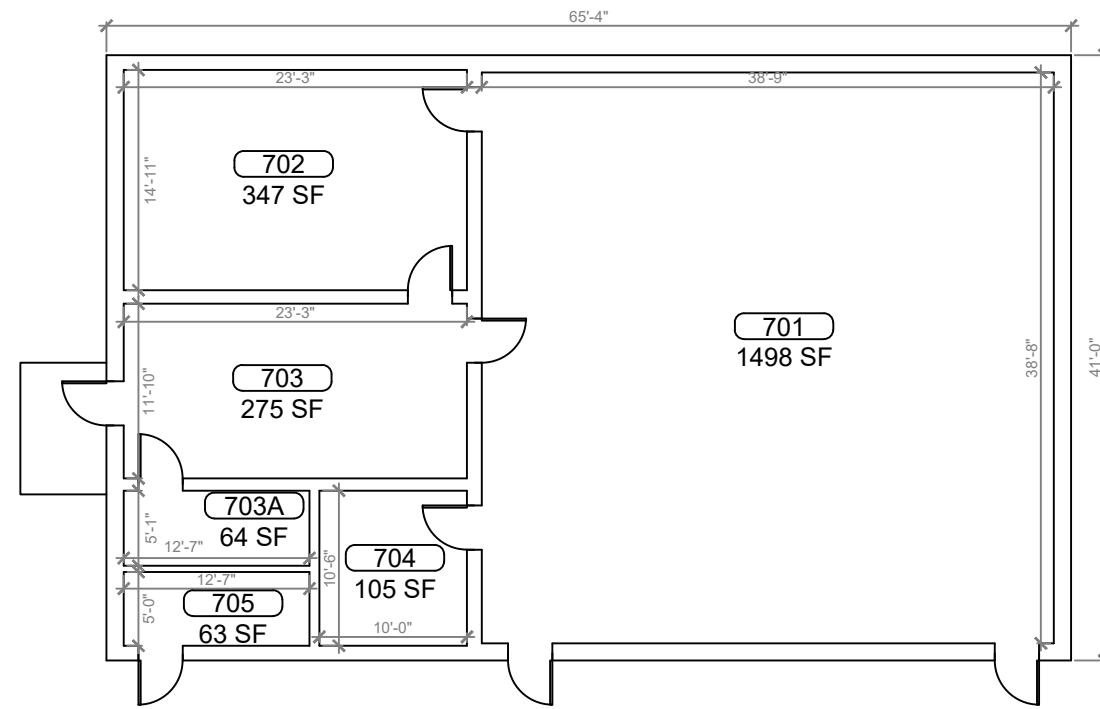

BUILDING 07 FLOOR PLAN
SCALE: 3/16"=1'-0"

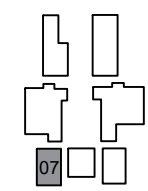


KEY PLAN

REV	DATE	DESCRIPTION
A	03/01/2021	PRELIMINARY FISH PLAN
B		
0		
1		
2		
3		
4		
5		
6		

ARCHIS PROJECT NO.:

DRAWN BY:	CHECKED BY:
VP	SH

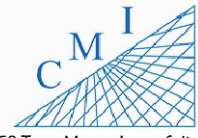

158 Terra Mango Loop, Suite B,
Orlando, FL 32835
Main: (407) 293-4168

PREPARED BY:



350 E. Crown Point Road, Suite 1100
Winter Garden, FL 34787
Main: 888.324.2557
Direct: 407.439.1594

DATE

, PE

FL PROFESSIONAL ENGINEER LIC. #

**LAKE TECHNICAL COLLEGE
INSTITUTE OF PUBLIC
SAFETY
(FISH PLAN)**

1565 Lane Park Cutoff Rd,
Tavares, FL

SHEET DESCRIPTION

BUILDING 07

SHEET NUMBER


B-06

ARCHIS TECHNOLOGIES - \\Server-1\h\Archis\21-043 Lake Tech Brag Center.dwg March 25, 2021 18:45:03 PC20




REV	DATE	DESCRIPTION
A	03/01/2021	PRELIMINARY FISH PLAN
B		
0		
1		
2		
3		
4		
5		
6		

ARCHIS PROJECT NO.:	
DRAWN BY:	CHECKED BY:
VP	SH

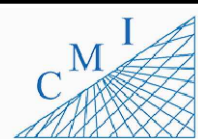


158 Terra Mango Loop, Suite B,
Orlando, FL 32835
Main: (407) 293-4168


PREPARED BY:
ARCHIS
350 E. Crown Point Road, Suite 1100
Winter Garden, FL 34787
Main: 888.324.2557
Direct: 407.439.1594

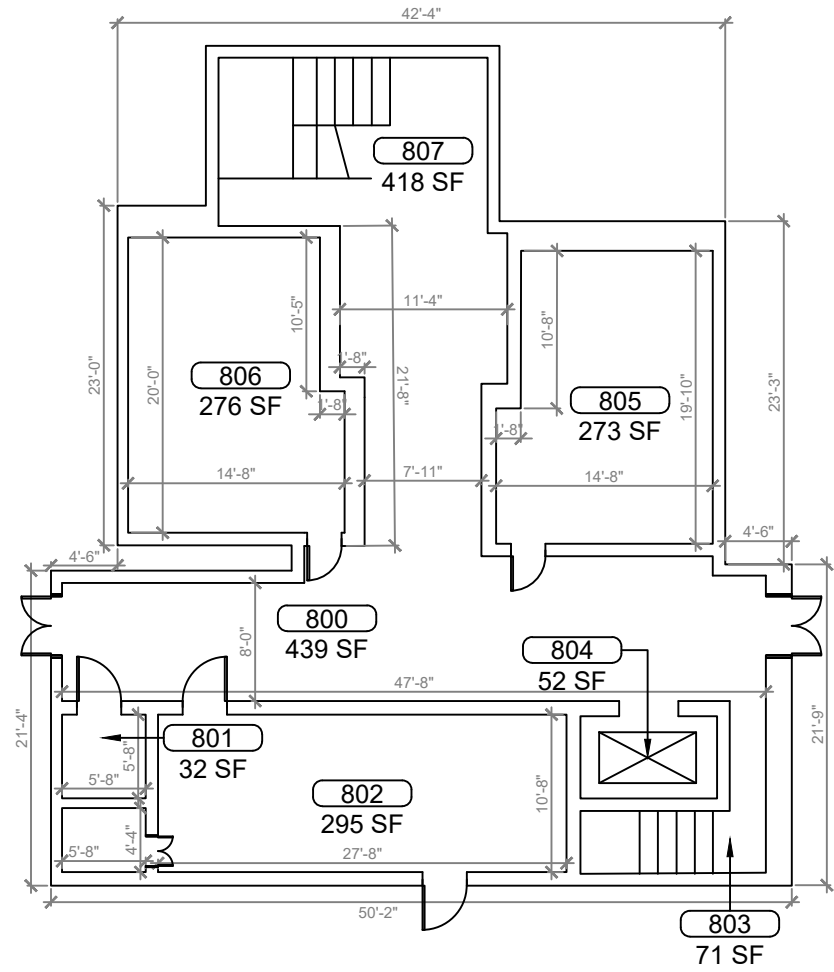


1 BUILDING 08 FIRST FLOOR PLAN
SCALE: 3/16"=1'-0"

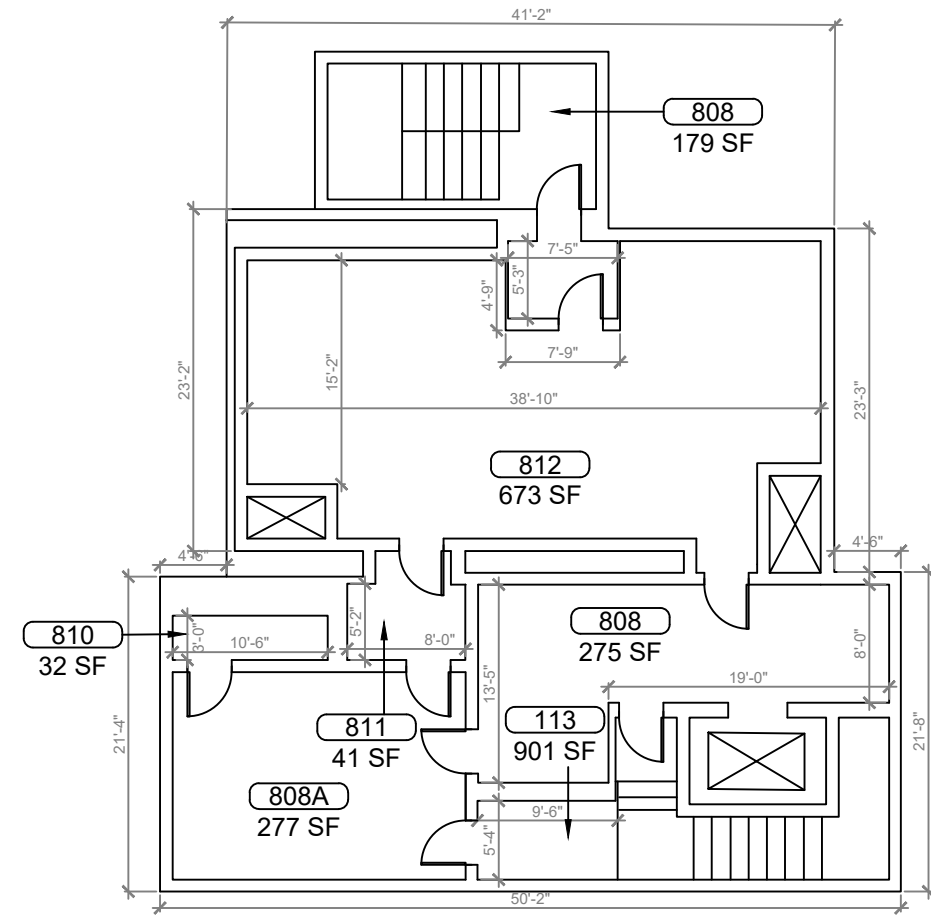

2 BUILDING 08 SECOND FLOOR PLAN
SCALE: 3/16"=1'-0"

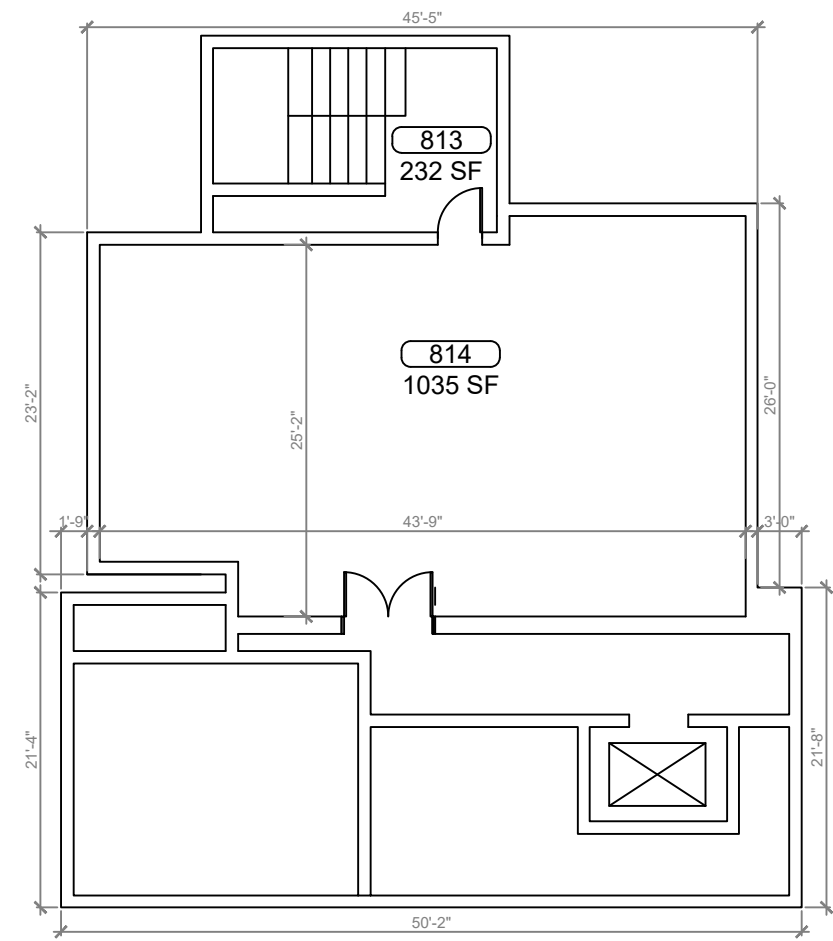

3 BUILDING 08 THIRD FLOOR PLAN
SCALE: 3/16"=1'-0"

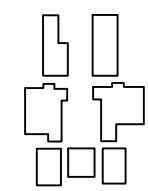

KEY PLAN

DATE
, PE
FL PROFESSIONAL ENGINEER LIC. #

**LAKE TECHNICAL COLLEGE
INSTITUTE OF PUBLIC
SAFETY
(FISH PLAN)**
1565 Lane Park Cutoff Rd,
Tavares, FL

SHEET DESCRIPTION
BUILDING 08

SHEET NUMBER
B-07

ARCHIS TECHNOLOGIES - \\Server-1\h\Archis\21-043 Lake Tech Brag Center.dwg Tech Brag Center.dwg March 25, 2021 18:45:08 PC20




REV	DATE	DESCRIPTION
A	03/01/2021	PRELIMINARY FISH PLAN
B		
0		
1		
2		
3		
4		
5		
6		

ARCHIS PROJECT NO.:	
DRAWN BY:	CHECKED BY:
VP	SH




PREPARED BY:


350 E. Crown Point Road, Suite 1100
Winter Garden, FL 34787
Main: 888.324.2557
Direct: 407.439.1594

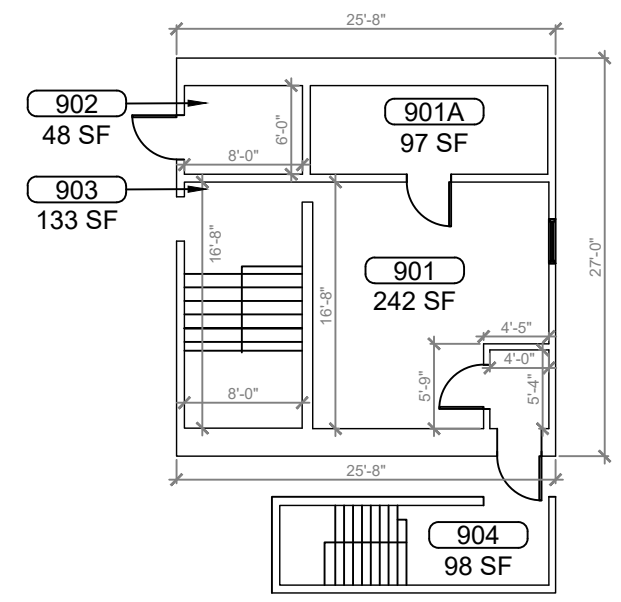


1 BUILDING 09 FIRST FLOOR
SCALE: 3/16"=1'-0"

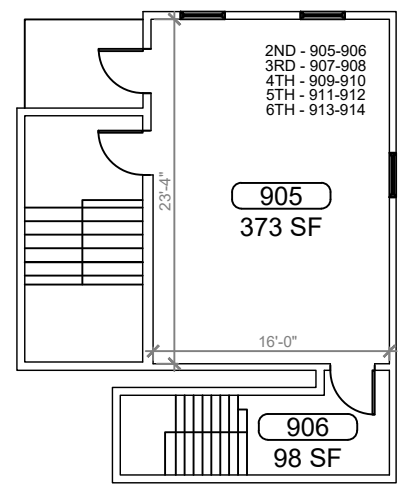

2 BUILDING 09 2ND TO 6TH FLOOR
SCALE: 3/16"=1'-0"

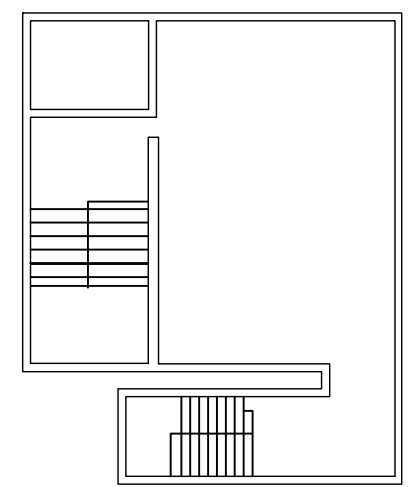

3 BUILDING 09 ROOF TOP
SCALE: 3/16"=1'-0"

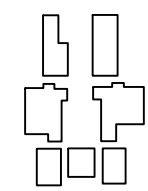


KEY PLAN

DATE
_____, **PE**
FL PROFESSIONAL ENGINEER LIC. # _____


**LAKE TECHNICAL COLLEGE
INSTITUTE OF PUBLIC
SAFETY
(FISH PLAN)**
1565 Lane Park Cutoff Rd,
Tavares, FL

SHEET DESCRIPTION
BUILDING 9
SHEET NUMBER
B-08


ARCHIS TECHNOLOGIES - \\Server-1\h\Archis\21-043 Lake Tech Brag Center\21-043 Lake Tech Survey_Lake County Fish Survey.dwg March 25, 2021 18:45:13 PC20

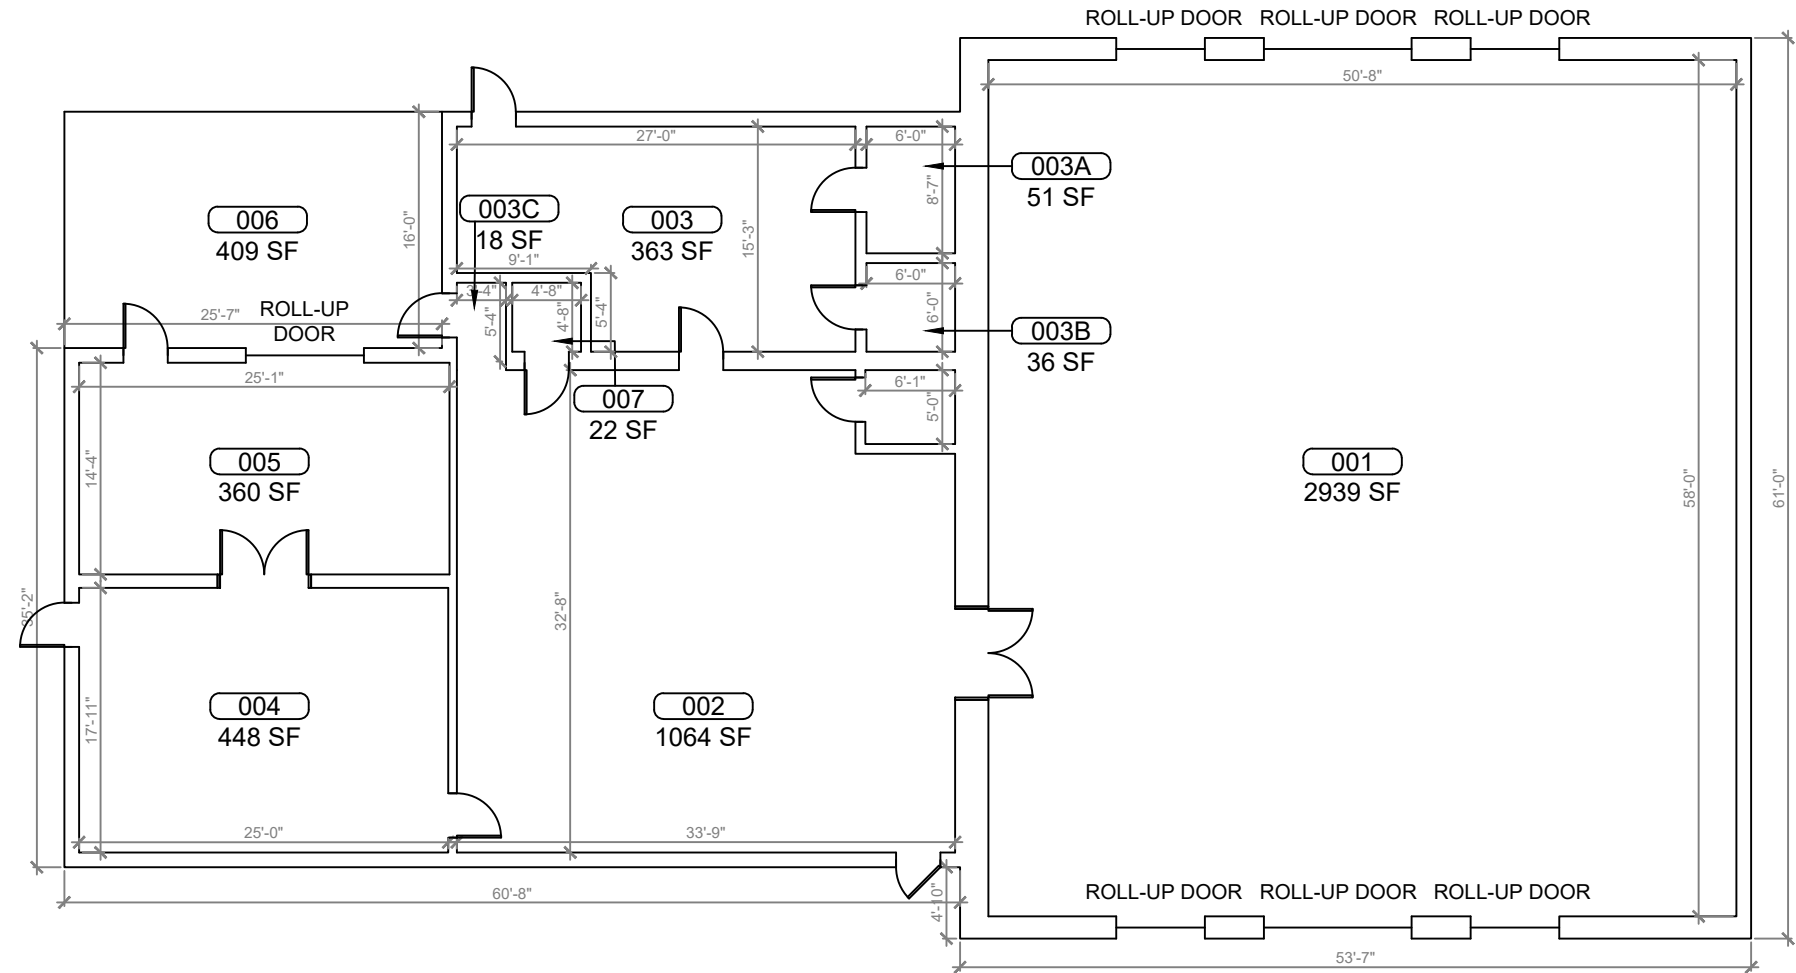

1 BUILDING 10 FLOOR PLAN
SCALE: 3/16"=1'-0"

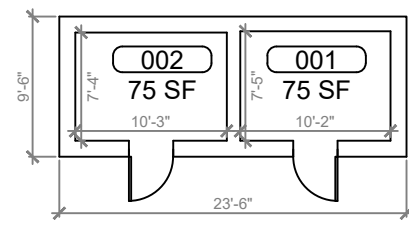

2 BUILDING 11 FLOOR PLAN
SCALE: 3/16"=1'-0"

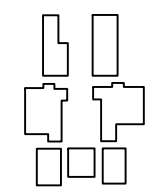

KEY PLAN

REV	DATE	DESCRIPTION
A	03/01/2021	PRELIMINARY FISH PLAN
B		
0		
1		
2		
3		
4		
5		
6		

ARCHIS PROJECT NO.:

DRAWN BY:	CHECKED BY:
VP	SH



158 Terra Mango Loop, Suite B,
Orlando, FL 32835
Main: (407) 293-4168

PREPARED BY:



350 E. Crown Point Road, Suite 1100
Winter Garden, FL 34787
Main: 888.324.2557
Direct: 407.439.1594

DATE

, PE

FL PROFESSIONAL ENGINEER LIC. #

**LAKE TECHNICAL COLLEGE
INSTITUTE OF PUBLIC
SAFETY**

(FISH PLAN)

1565 Lane Park Cutoff Rd,
Tavares, FL

SHEET DESCRIPTION

**BUILDING 10 &
11**

SHEET NUMBER

B-09