


SPRING CREEK CHARTER

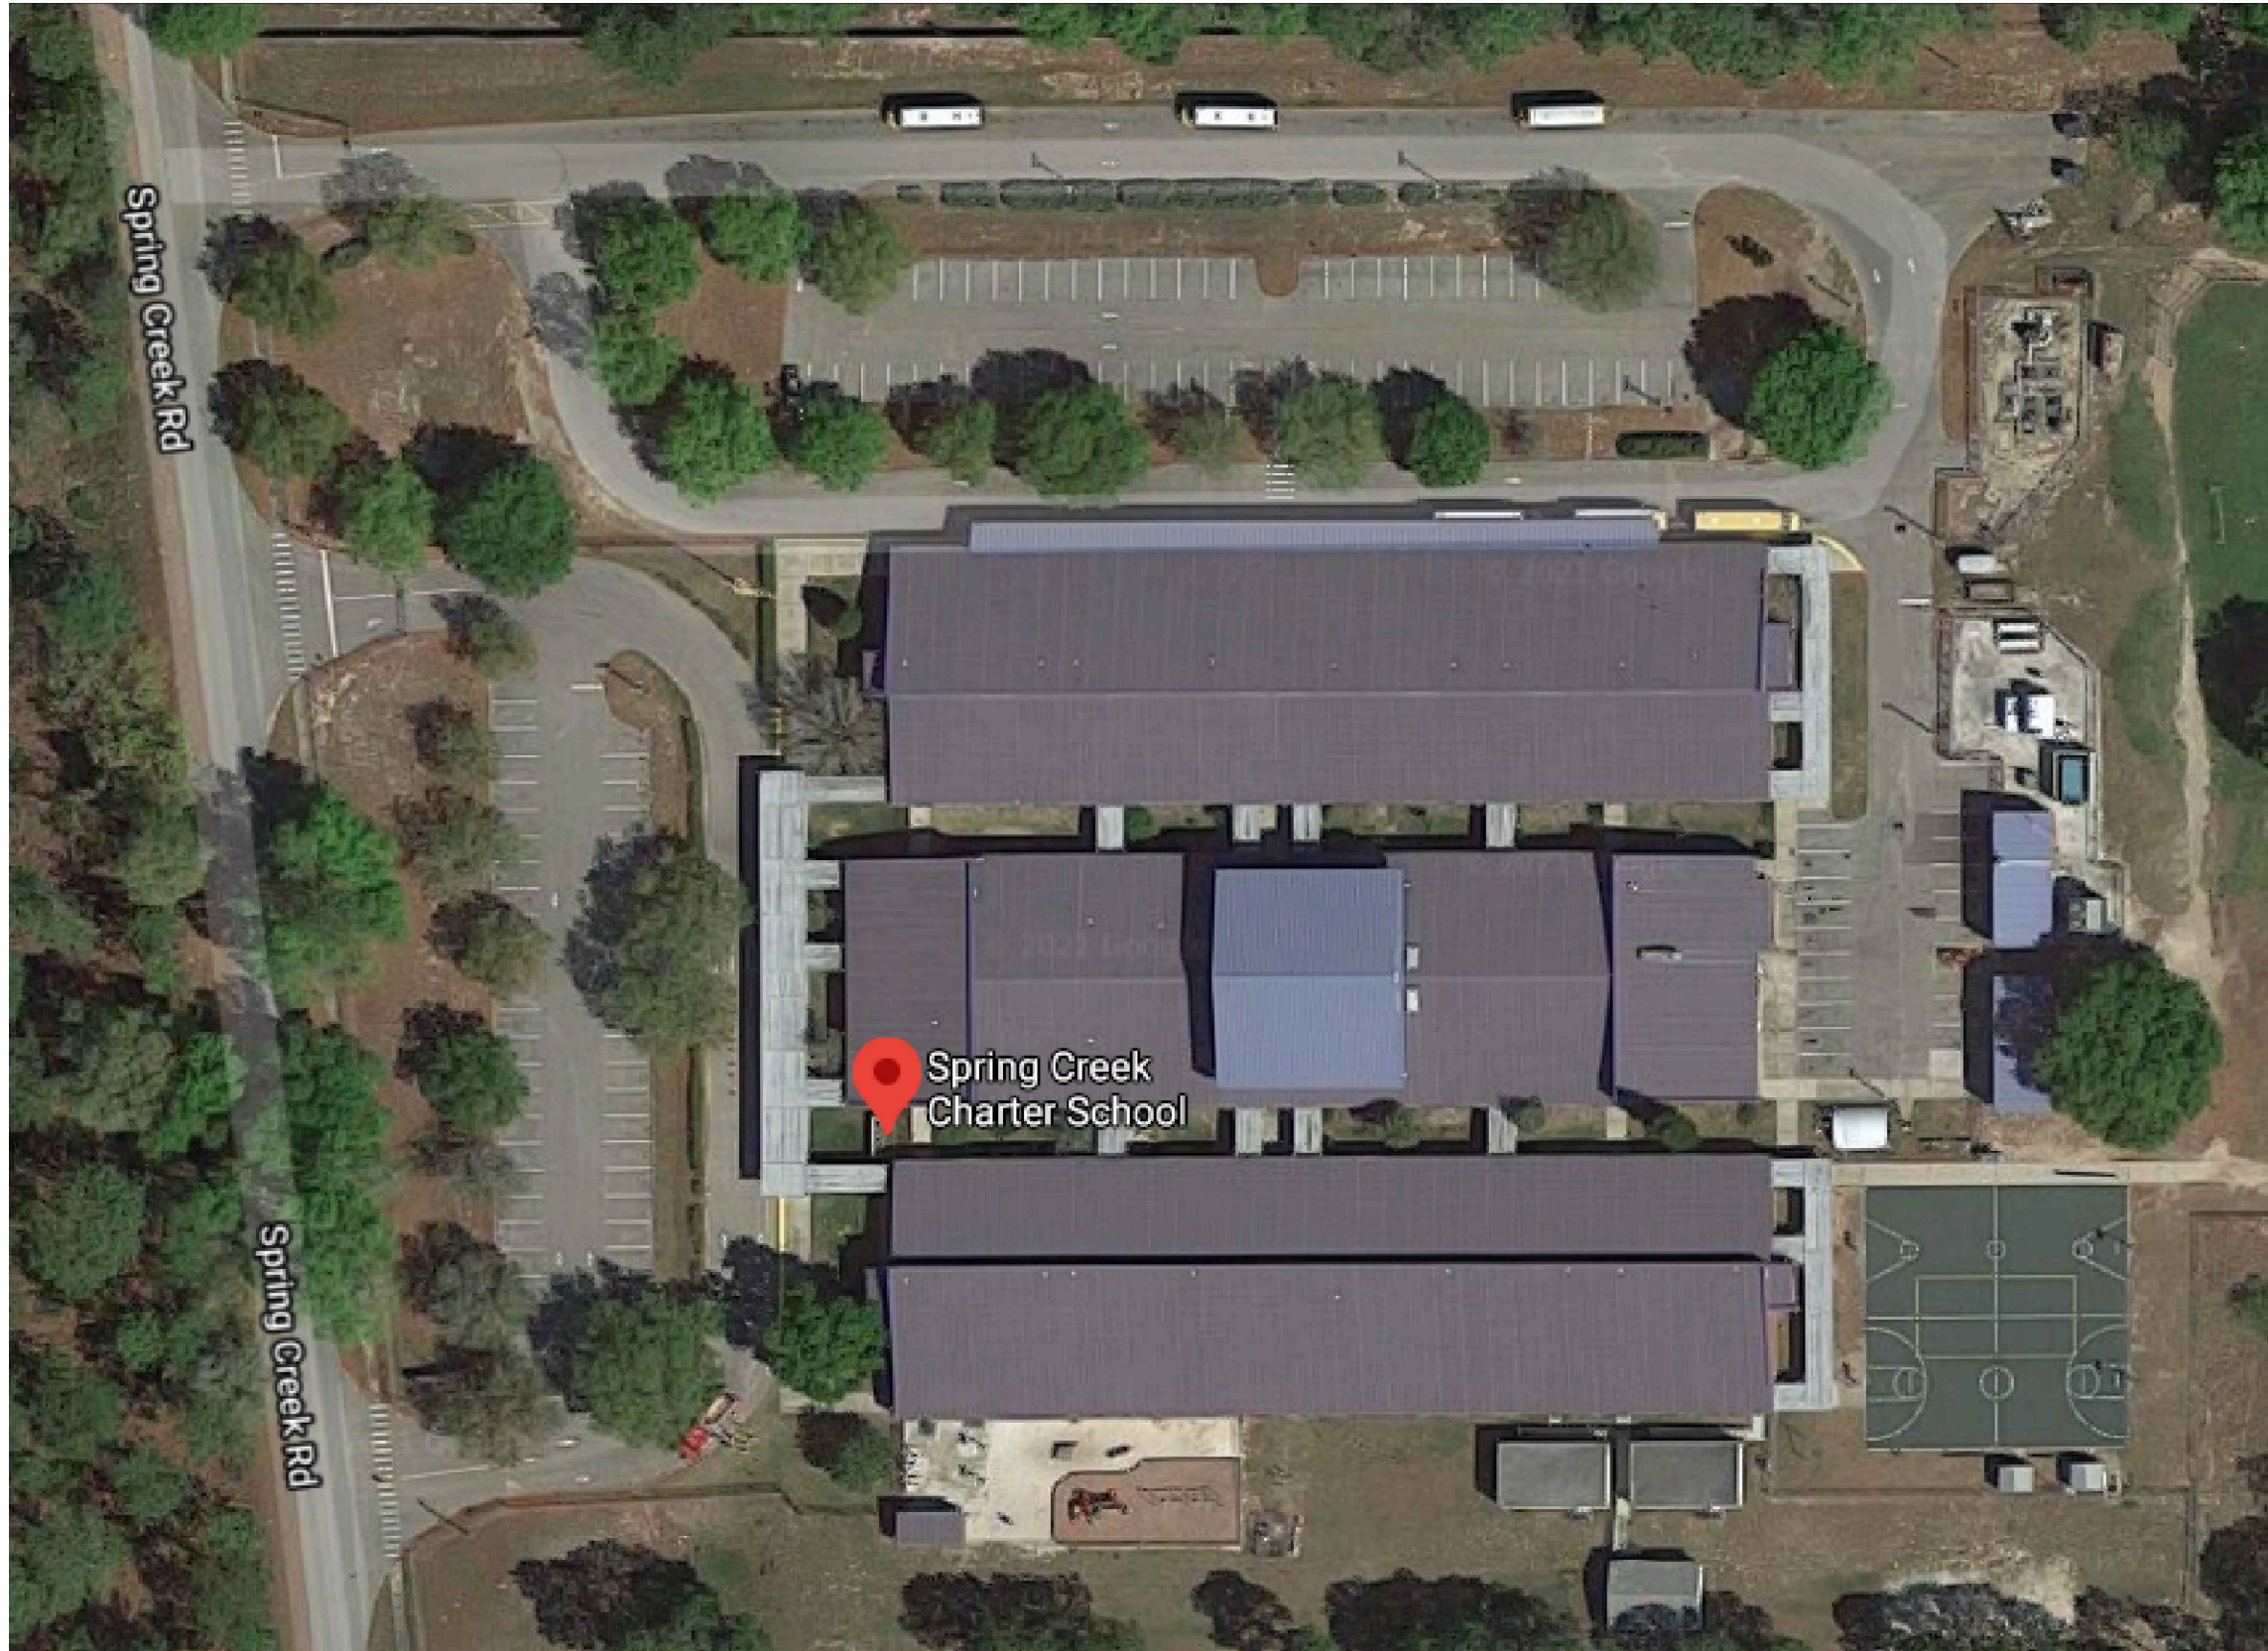


INDEX OF DRAWINGS

SHT. NO.	DESCRIPTION
SP-01	AERIAL
SP-02	SITE PLAN
B-01	BUILDING 01
B-02	BUILDING 02
B-03	BUILDING 03
B-04	BUILDING 04
B-05	BUILDING 05
B-06	BUILDING 06
B-07	BUILDING 07, 08 & 09

REV	DATE	DESCRIPTION
A	02/24/21	PRELIMINARY FISH PLAN
B		
0		
1		
2		
3		
4		
5		
6		

ARCHIS PROJECT NO.:	
DRAWN BY: YP	CHECKED BY: SH

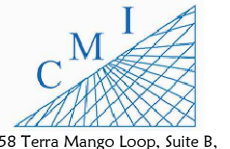

158 Terra Mango Loop, Suite B,
Orlando, FL 32835
Main: (407) 293-4168

PREPARED BY:

350 E. Crown Point Road, Suite 1100
Winter Garden, FL 34787
Main: 888.324.2557
Direct: 407.439.1594

DATE
, PE
FL PROFESSIONAL ENGINEER LIC. #

**Spring Creek
Charter School
(FISH PLAN)**

44440 Spring Creek
Rd, Paisley, FL 32767

SHEET DESCRIPTION

AERIAL VIEW

SHEET NUMBER

SP-01


1
SP-01 **AERIAL VIEW**
SCALE: N.T.S.

ARCHIS TECHNOLOGIES - \\server-1\H\Archis\21-038 Spring Creek Charter\From ISP\2021-02-25\896_Lake County_Fish Survey_Spring Creek Charter.dwg February 26, 2021 10:00:25 PC20

ARCHIS TECHNOLOGIES - \\server-1\H\Archis\21-038 Spring Creek Charter\From ISP\2021-02-25\896_Lake County_Fish Survey_Spring Creek Charter.dwg February 26, 2021 10:00:31 PC20

LEGEND

- 01 – ADMINISTRATION / MEDIA
- 02 – CLASSROOM
- 03 – CLASSROOM
- 04 – CAFETERIA
- 05 – CLASSROOM
- 06 – CLASSROOM
- 07 – STORAGE
- 08 – STORAGE
- 09 – STORAGE
- 99 – PORTABLE

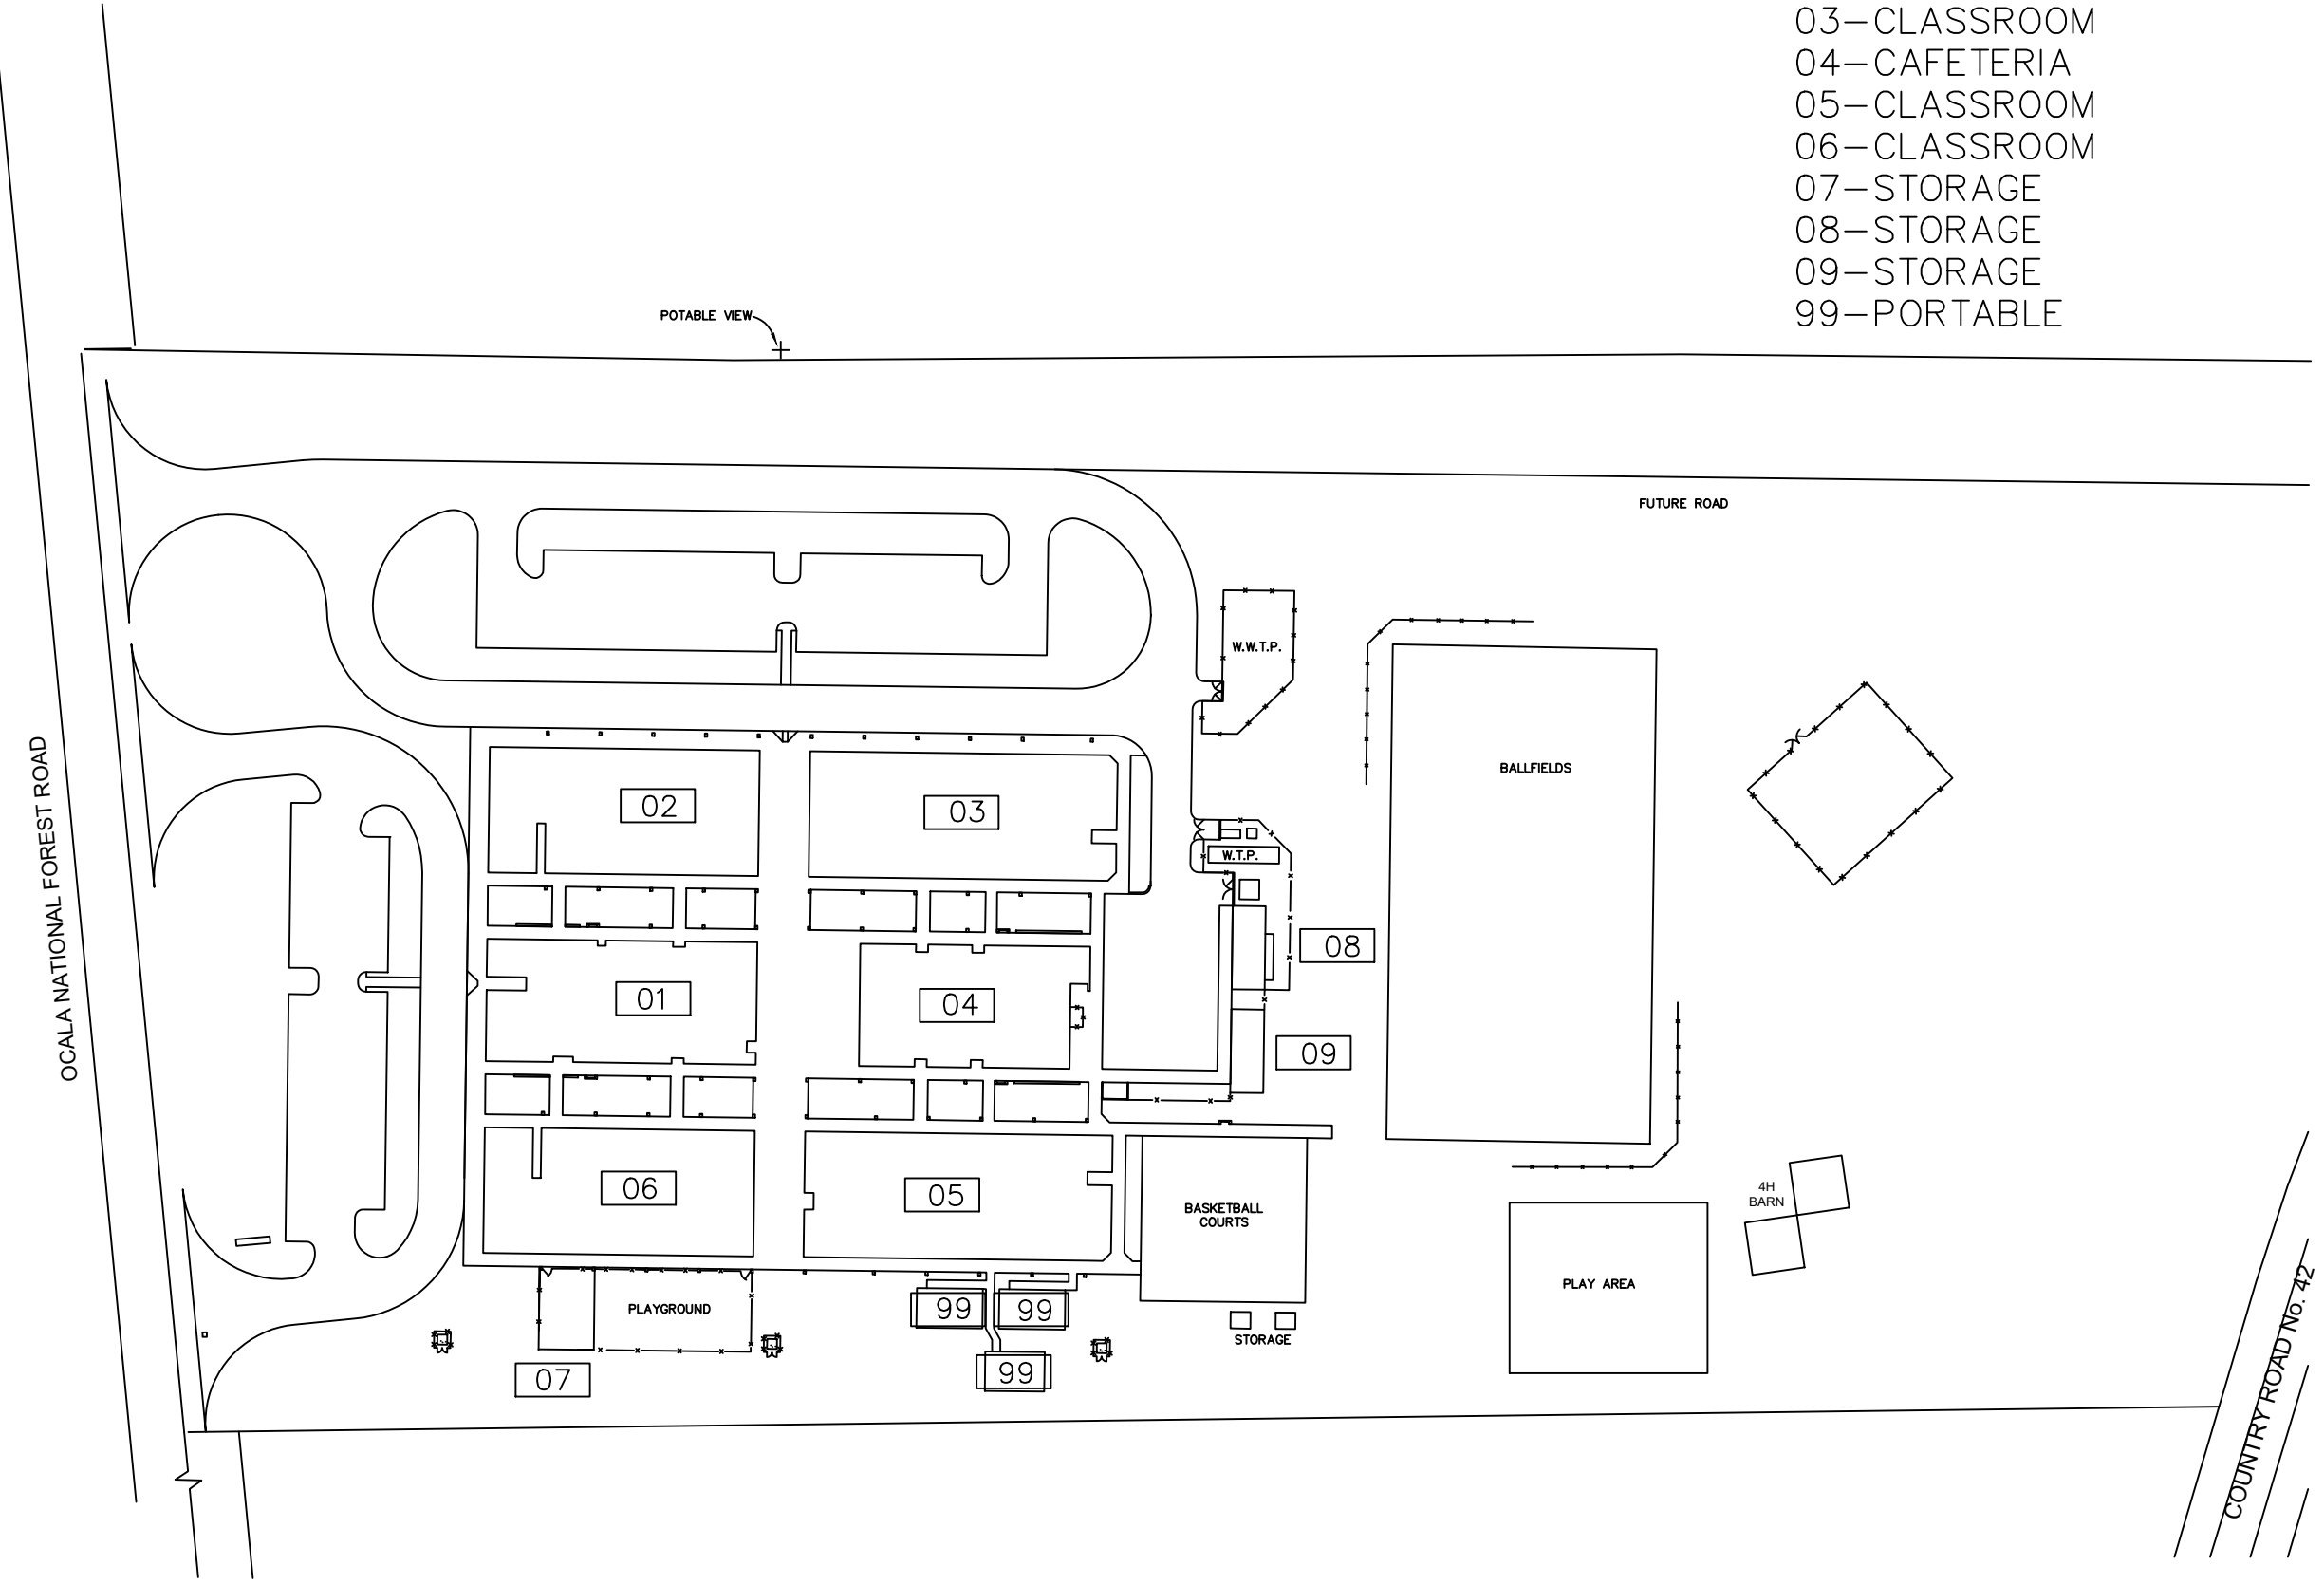

REV	DATE	DESCRIPTION
A	02/24/21	PRELIMINARY FISH PLAN
B		
0		
1		
2		
3		
4		
5		
6		

ARCHIS PROJECT NO.:	
DRAWN BY:	CHECKED BY:
YP	SH



CMI
 158 Terra Mango Loop, Suite B,
 Orlando, FL 32835
 Main: (407) 293-4168

PREPARED BY:
ARCHIS
 350 E. Crown Point Road, Suite 1100
 Winter Garden, FL 34787
 Main: 888.324.2557
 Direct: 407.439.1594


DATE _____
 , PE
 FL PROFESSIONAL ENGINEER LIC. # _____

Spring Creek Charter School (FISH PLAN)
 44440 Spring Creek Rd, Paisley, FL 32767
 SHEET DESCRIPTION
OVERALL SITE PLAN

SHEET NUMBER
SP-02

1 OVERALL SITE PLAN
 SP-02 SCALE: N.T.S.

ARCHIS TECHNOLOGIES - \\server-1\H\Archis\21-038 Spring Creek Charter\From ISP\2021-02-25\896_Lake County_Fish Survey_Spring Creek Charter.dwg February 26, 2021 10:00:33 PC20

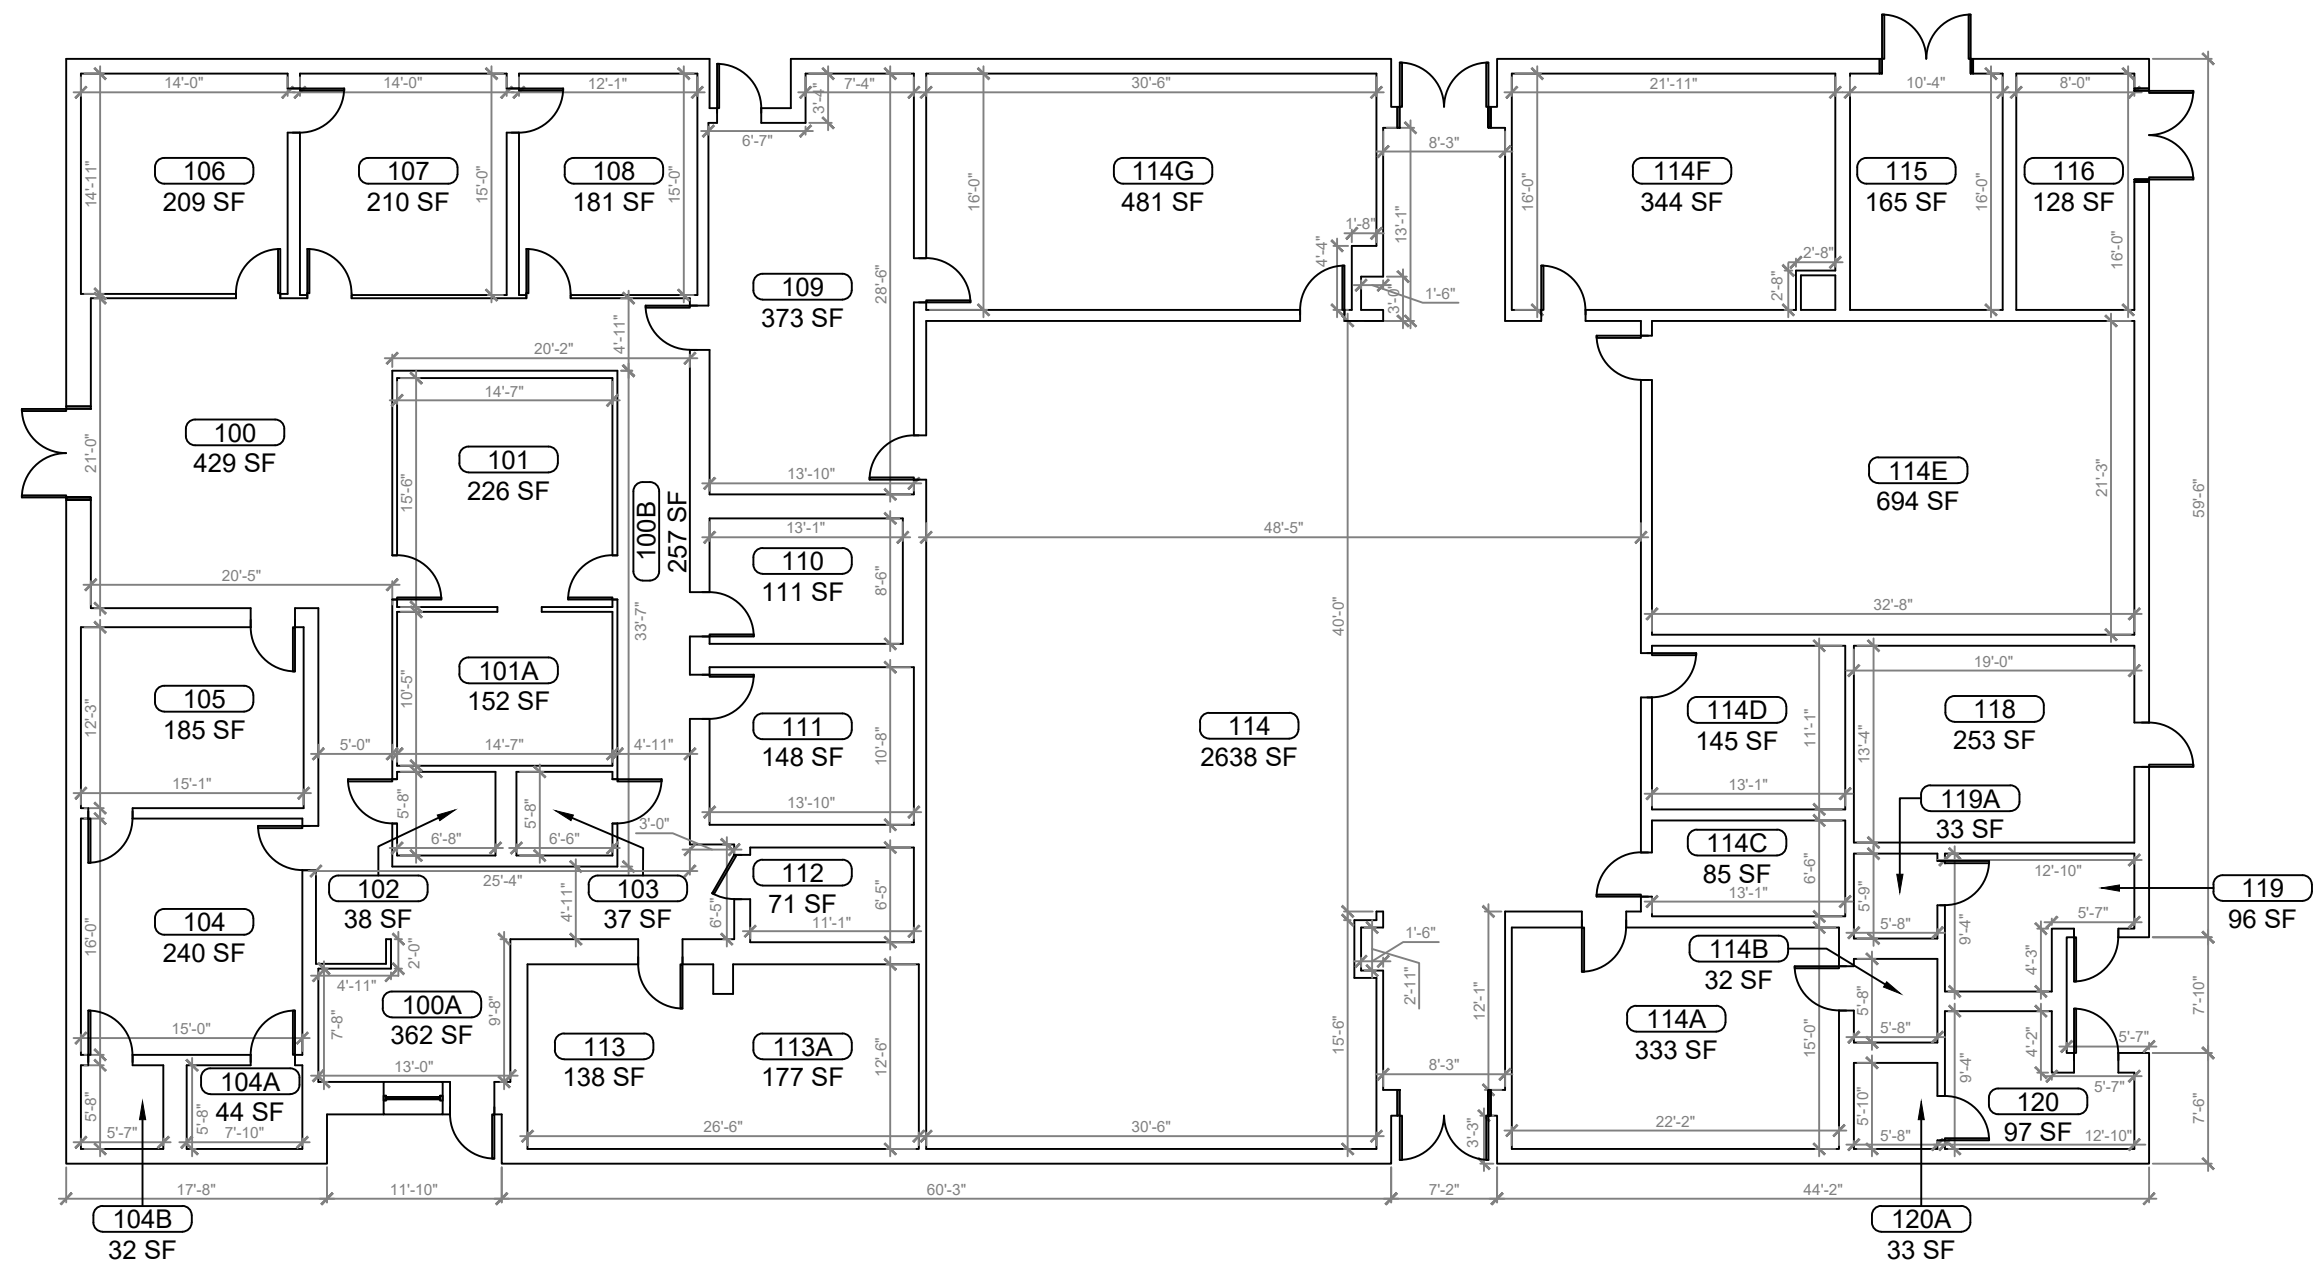

REV	DATE	DESCRIPTION
A	02/24/21	PRELIMINARY FISH PLAN
B		
0		
1		
2		
3		
4		
5		
6		

ARCHIS PROJECT NO.:	
DRAWN BY:	CHECKED BY:
YP	SH



CMI
 158 Terra Mango Loop, Suite B,
 Orlando, FL 32835
 Main: (407) 293-4168

PREPARED BY:


 350 E. Crown Point Road, Suite 1100
 Winter Garden, FL 34787
 Main: 888.324.2557
 Direct: 407.439.1594

DATE _____
 _____, PE
 FL PROFESSIONAL ENGINEER LIC. # _____


Spring Creek Charter School (FISH PLAN)
 44440 Spring Creek Rd, Paisley, FL 32767
 SHEET DESCRIPTION
BUILDING 01

SHEET NUMBER
B-01


1 BUILDING 01 FLOOR PLAN
 SCALE: 3/16"=1'-0"

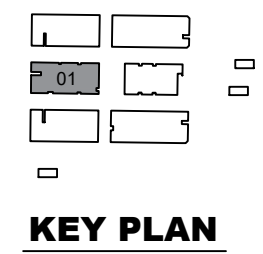

ARCHIS TECHNOLOGIES - \\server-1\H\Archis\21-038 Spring Creek Charter\From ISP\2021-02-25\896_Lake County_Spring Creek Charter.dwg February 26, 2021 10:00:38 PC20

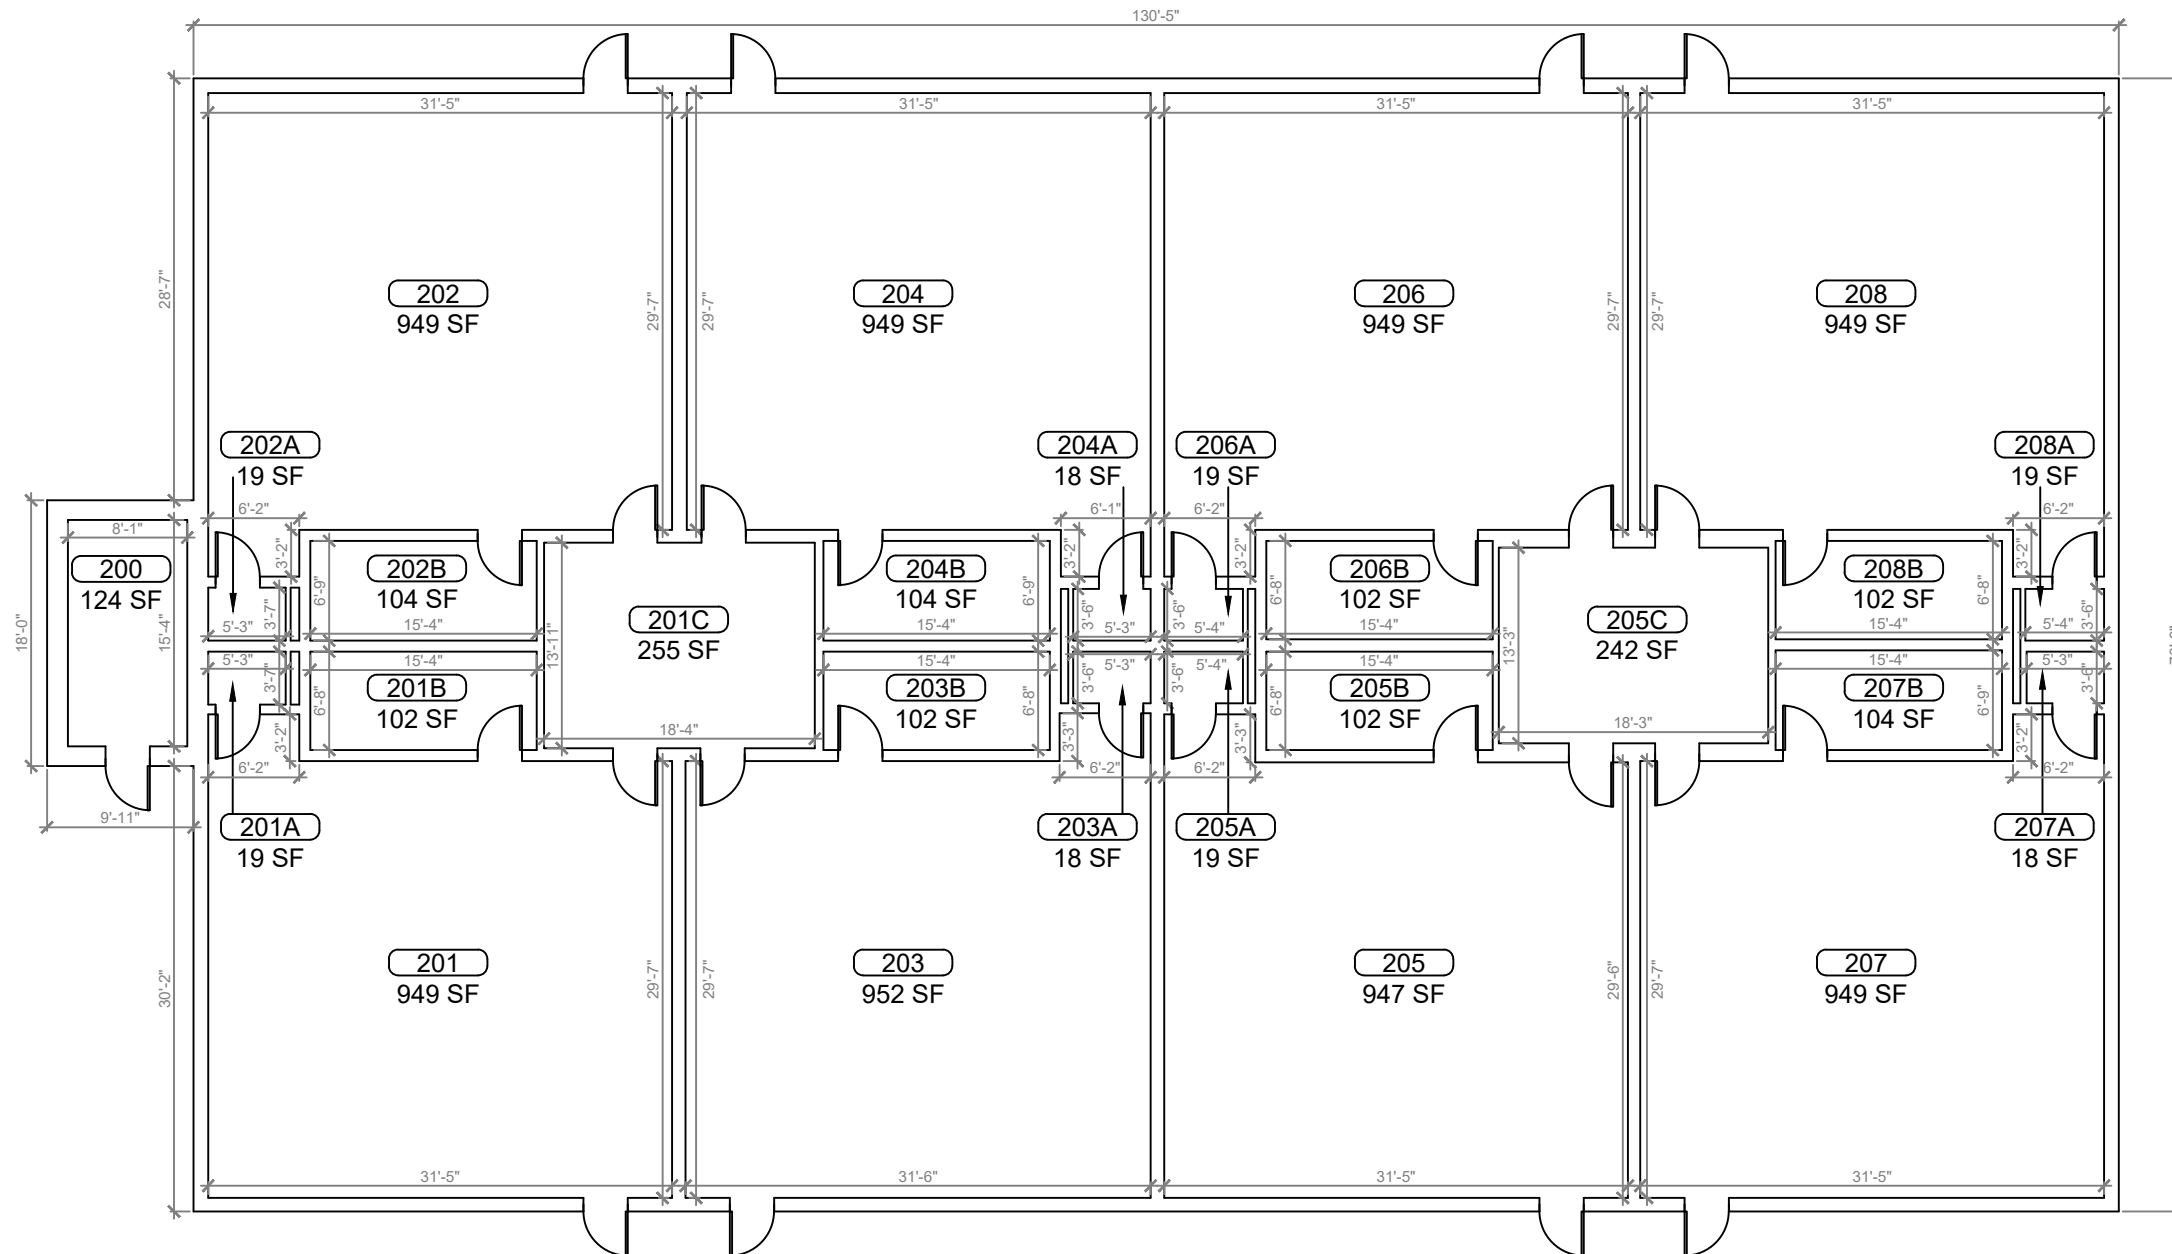

1
B-02 **BUILDING 02 FLOOR PLAN**
SCALE: 3/16"=1'-0"

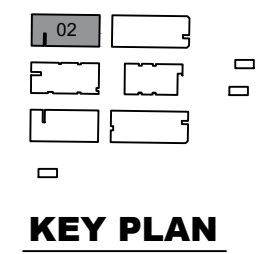

REV	DATE	DESCRIPTION
A	02/24/21	PRELIMINARY FISH PLAN
B		
0		
1		
2		
3		
4		
5		
6		

ARCHIS PROJECT NO.:	
DRAWN BY:	CHECKED BY:
YP	SH



158 Terra Mango Loop, Suite B,
Orlando, FL 32835
Main: (407) 293-4168

PREPARED BY:



350 E. Crown Point Road, Suite 1100
Winter Garden, FL 34787
Main: 888.324.2557
Direct: 407.439.1594

DATE

, PE

FL PROFESSIONAL ENGINEER LIC. #

**Spring Creek
Charter School
(FISH PLAN)**

44440 Spring Creek
Rd, Paisley, FL 32767


SHEET DESCRIPTION

BUILDING 02


SHEET NUMBER

B-02

ARCHIS TECHNOLOGIES - \\server-1\H\Archis\21-038 Spring Creek Charter\From ISP\2021-02-25\896_Lake County_Spring Creek Charter.dwg February 26, 2021 10:00:43 PC20

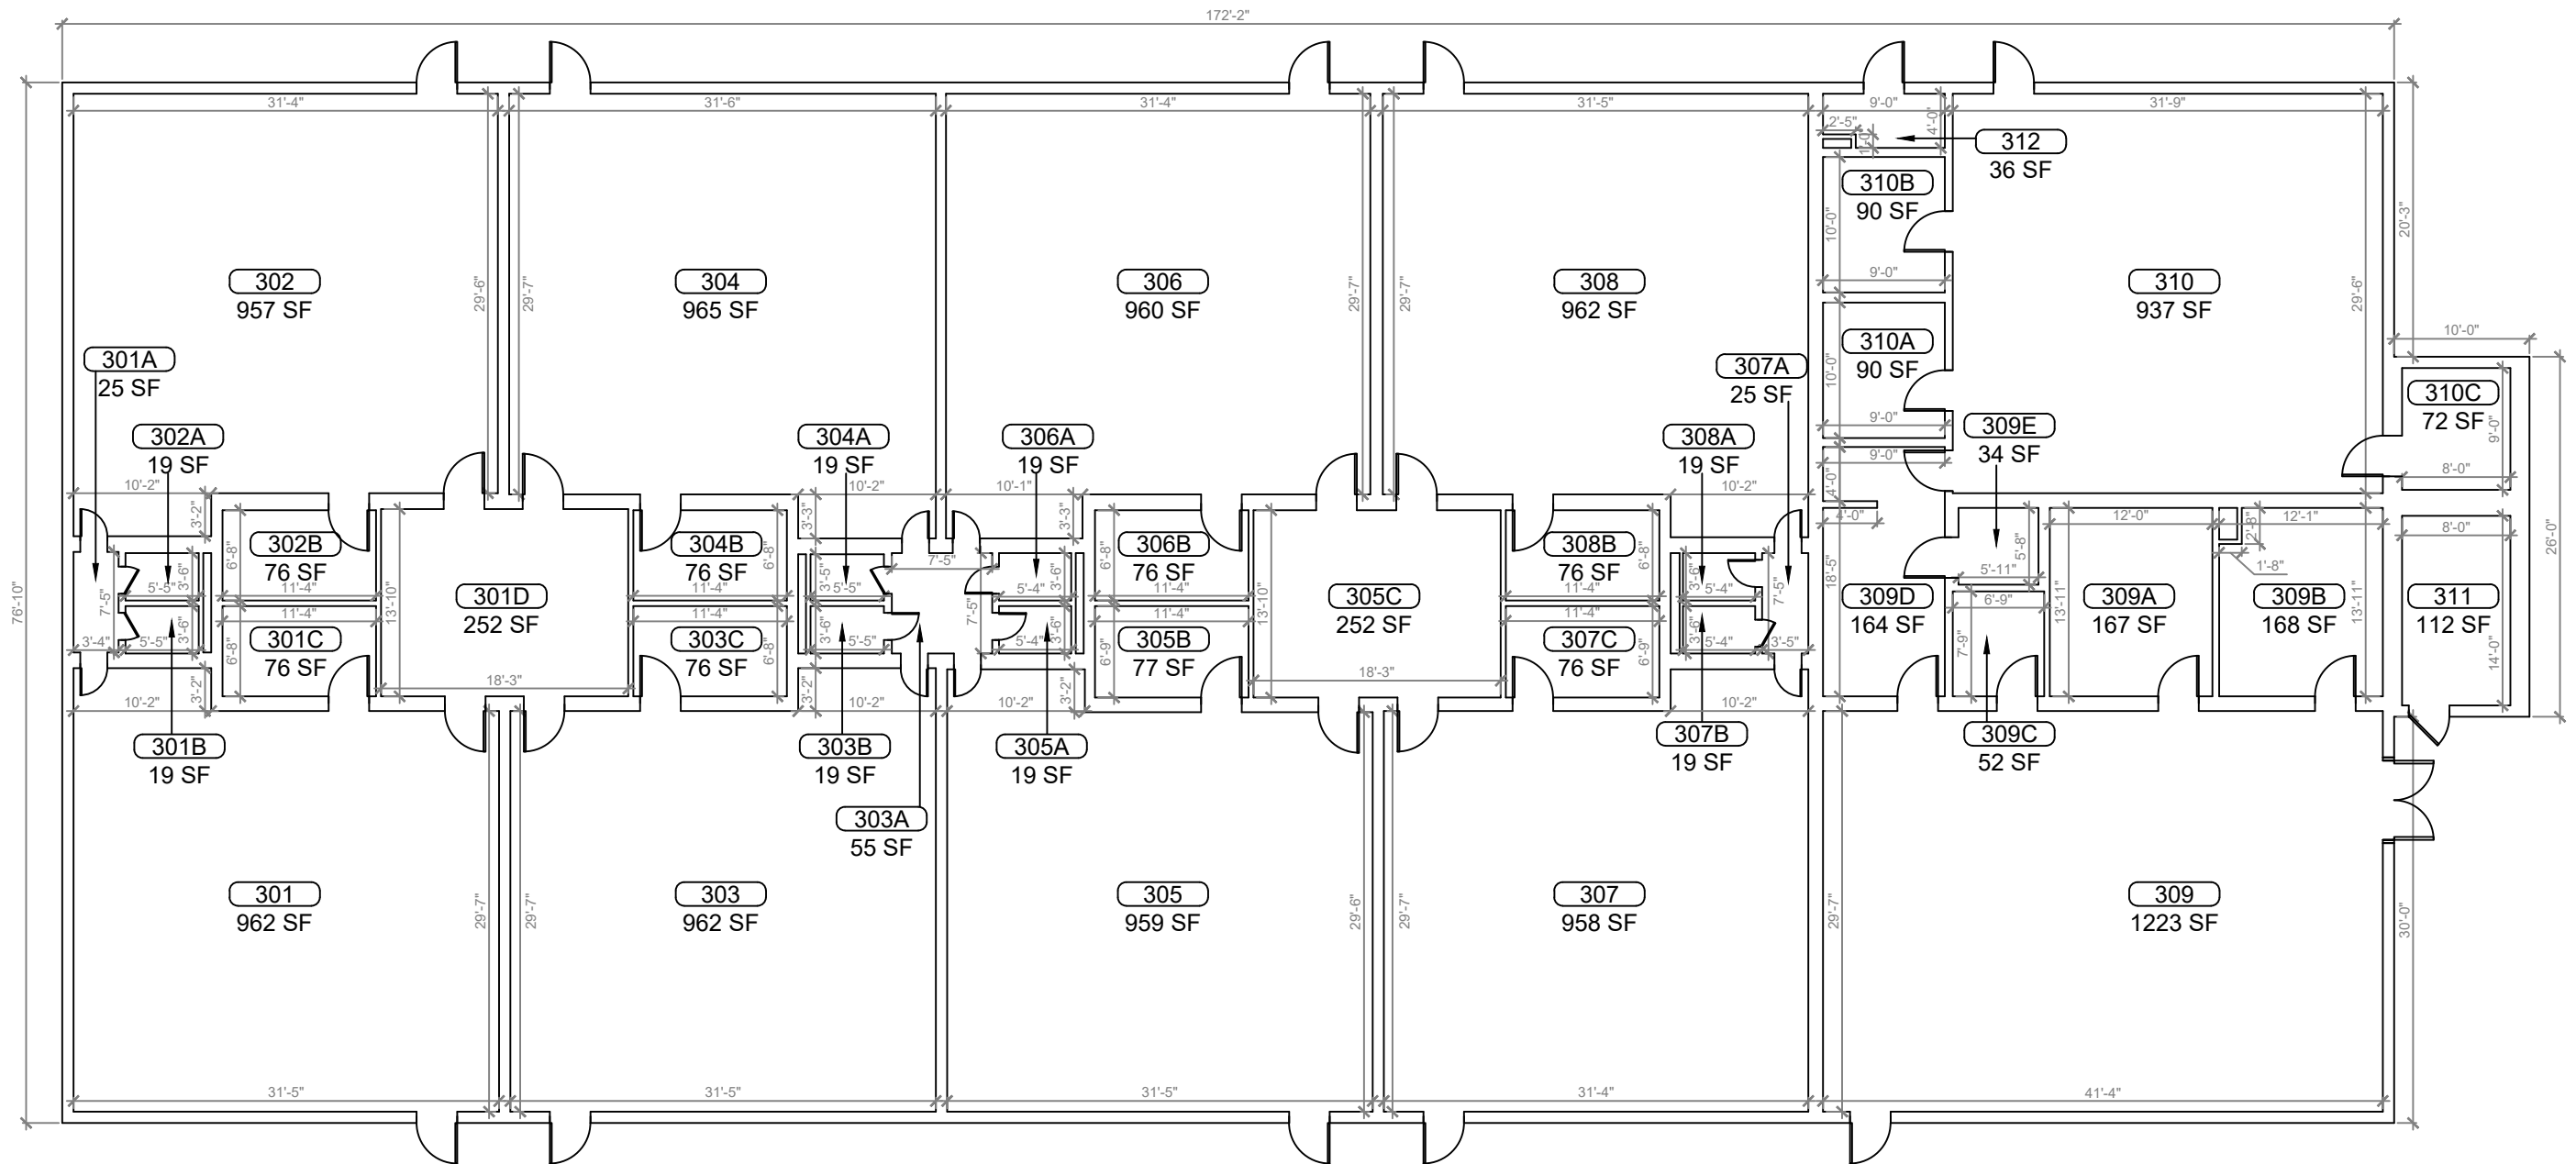


1 BUILDING 03 FLOOR PLAN
SCALE: 3/16"=1'-0"

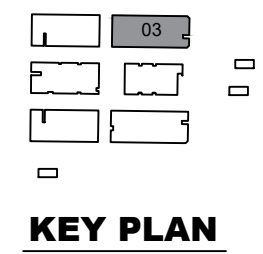

REV	DATE	DESCRIPTION
A	02/24/21	PRELIMINARY FISH PLAN
B		
0		
1		
2		
3		
4		
5		
6		

ARCHIS PROJECT NO.:	
DRAWN BY:	CHECKED BY:
YP	SH

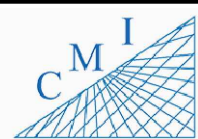

158 Terra Mango Loop, Suite B,
Orlando, FL 32835
Main: (407) 293-4168

PREPARED BY:



350 E. Crown Point Road, Suite 1100
Winter Garden, FL 34787
Main: 888.324.2557
Direct: 407.439.1594

DATE

, PE

FL PROFESSIONAL ENGINEER LIC. #

**Spring Creek
Charter School
(FISH PLAN)**

44440 Spring Creek
Rd, Paisley, FL 32767


SHEET DESCRIPTION

BUILDING 03


SHEET NUMBER

B-03

ARCHIS TECHNOLOGIES - \\server-1\H\Archis\21-038 Spring Creek Charter\21-038 Spring Creek Charter.dwg February 26, 2021 10:00:48 PC20

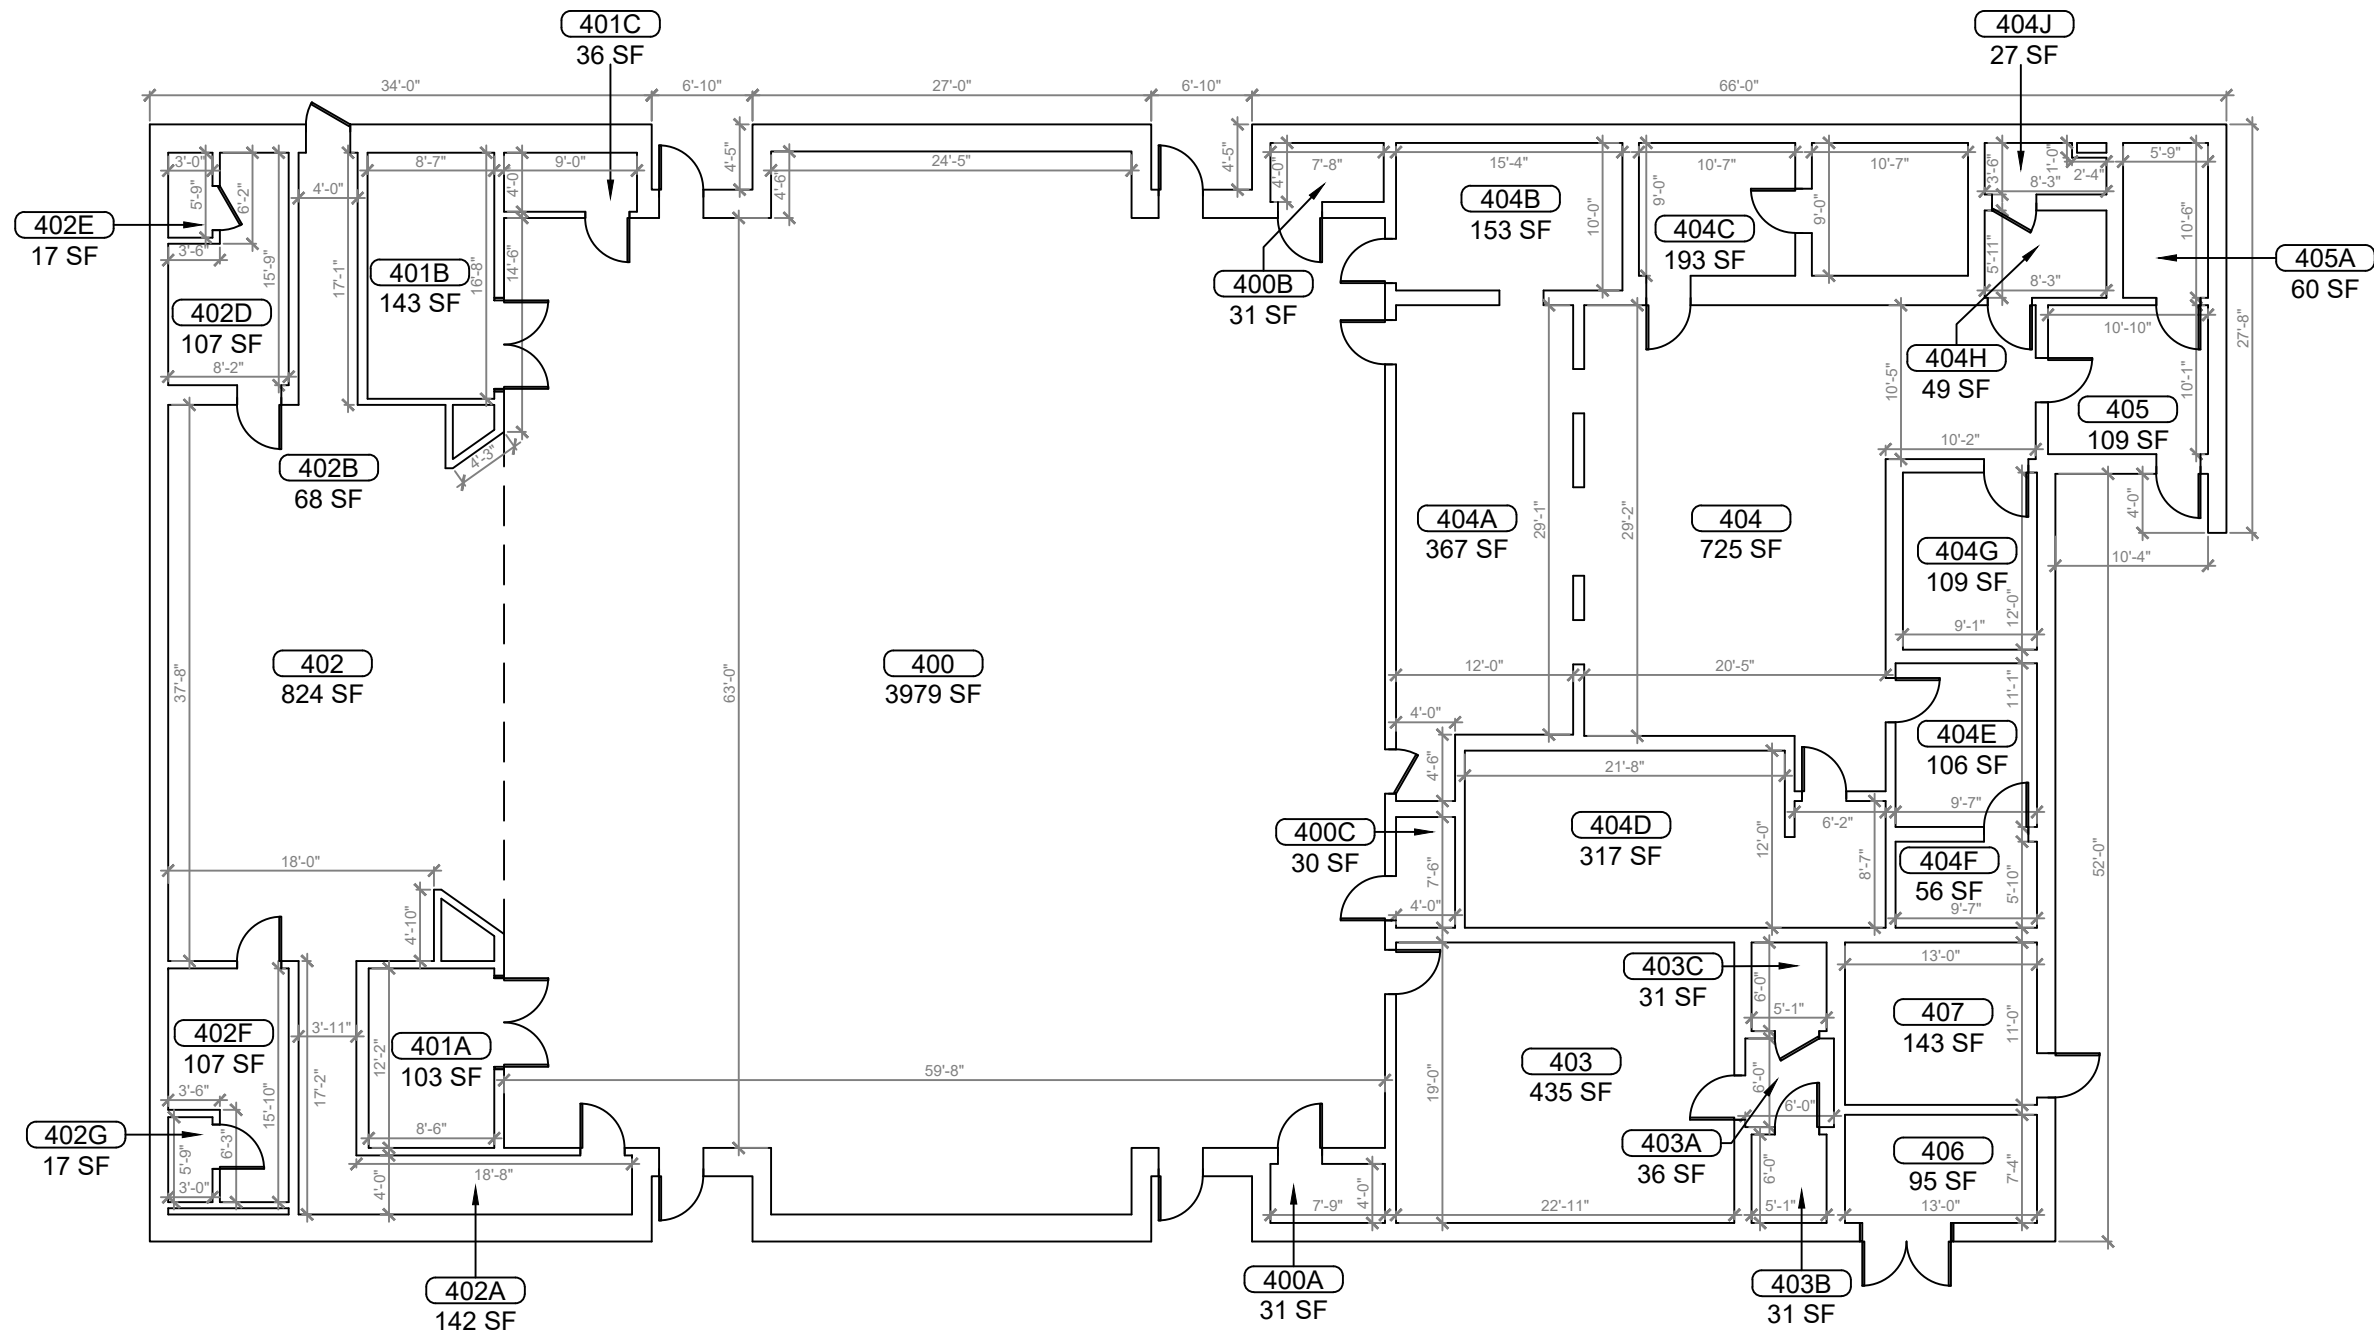

1 BUILDING 04 FLOOR PLAN
SCALE: 3/16"=1'-0"

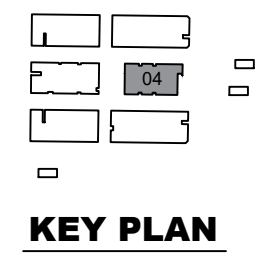

REV	DATE	DESCRIPTION
A	02/24/21	PRELIMINARY FISH PLAN
B		
0		
1		
2		
3		
4		
5		
6		

ARCHIS PROJECT NO.:

DRAWN BY:	CHECKED BY:
YP	SH



CMI
158 Terra Mango Loop, Suite B,
Orlando, FL 32835
Main: (407) 293-4168

PREPARED BY:
ARCHIS
350 E. Crown Point Road, Suite 1100
Winter Garden, FL 34787
Main: 888.324.2557
Direct: 407.439.1594


DATE
, PE
FL PROFESSIONAL ENGINEER LIC. #

**Spring Creek
Charter School
(FISH PLAN)**
44440 Spring Creek
Rd, Paisley, FL 32767


SHEET DESCRIPTION
BUILDING 04

SHEET NUMBER
B-04

ARCHIS TECHNOLOGIES - \\server-1\H\Archis\21-038 Spring Creek Charter\From ISP\2021-02-25\896_Lake County_Fish Survey_Spring Creek Charter.dwg February 26, 2021 10:00:53 PC20

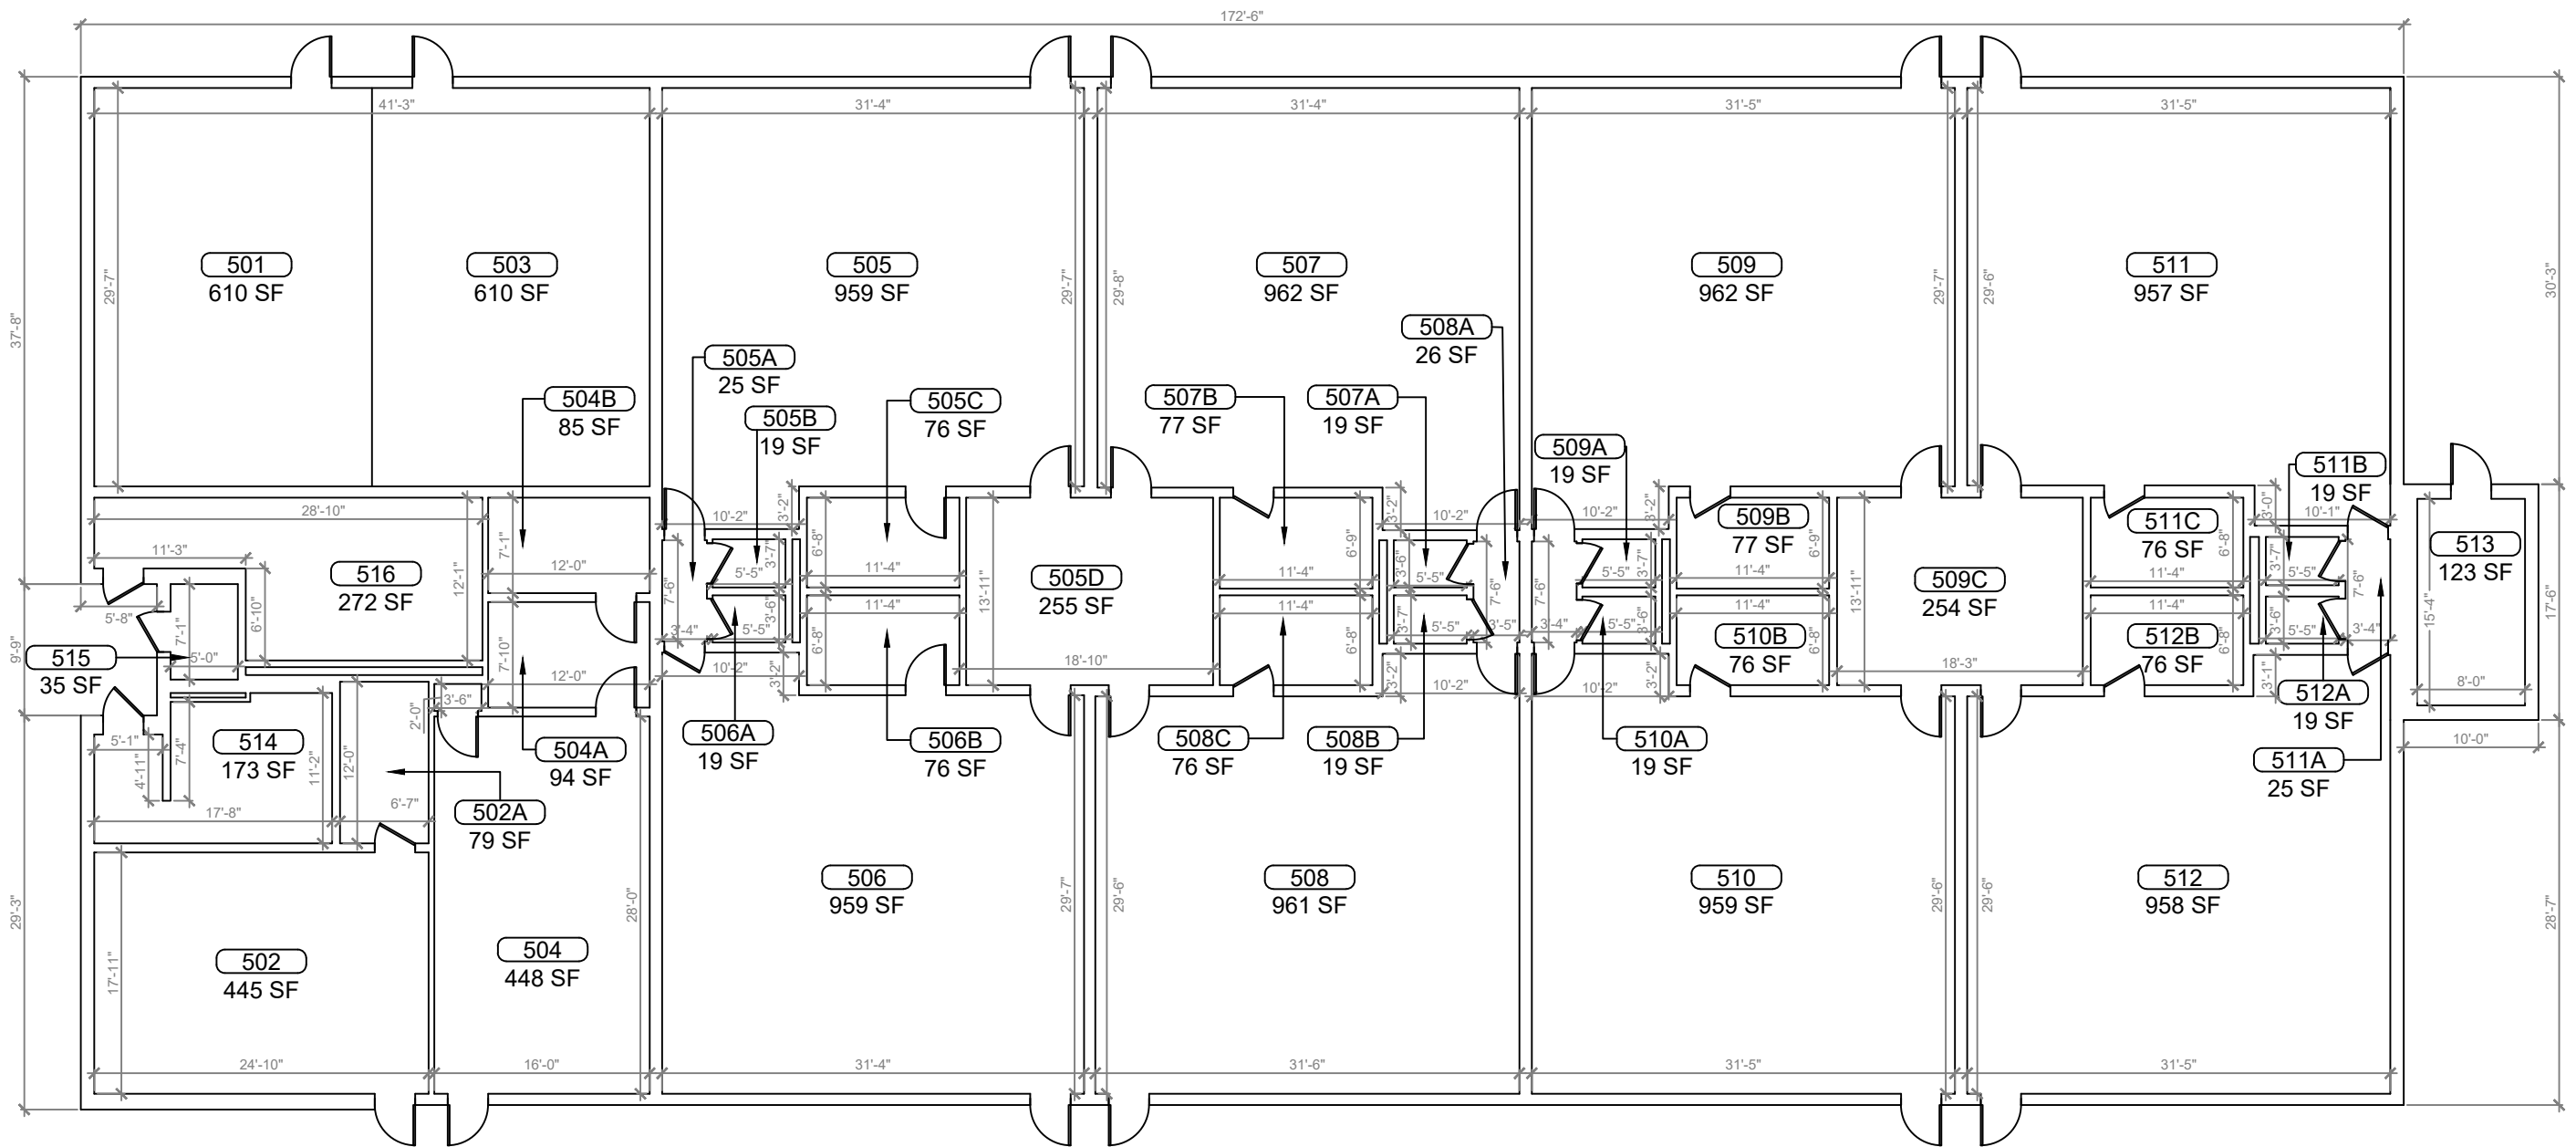

1 BUILDING 05 FIRST FLOOR PLAN
 B-05 SCALE: 3/16"=1'-0"

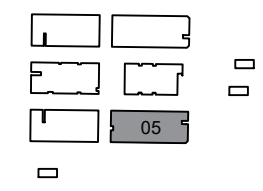

KEY PLAN

REV	DATE	DESCRIPTION
A	02/24/21	PRELIMINARY FISH PLAN
B		
0		
1		
2		
3		
4		
5		
6		

ARCHIS PROJECT NO.:	
DRAWN BY:	CHECKED BY:
YP	SH



C M I
 158 Terra Mango Loop, Suite B,
 Orlando, FL 32835
 Main: (407) 293-4168

PREPARED BY:
ARCHIS
 350 E. Crown Point Road, Suite 1100
 Winter Garden, FL 34787
 Main: 888.324.2557
 Direct: 407.439.1594

DATE
 , PE
 FL PROFESSIONAL ENGINEER LIC. #


**Spring Creek
 Charter School
 (FISH PLAN)**

44440 Spring Creek
 Rd, Paisley, FL 32767


SHEET DESCRIPTION
BUILDING 05

SHEET NUMBER
B-05

ARCHIS TECHNOLOGIES - \\server-1\H\Archis\21-038 Spring Creek Charter\From ISP\2021-02-25\896_Lake County_Spring Creek Charter.dwg February 26, 2021 10:00:58 PC20

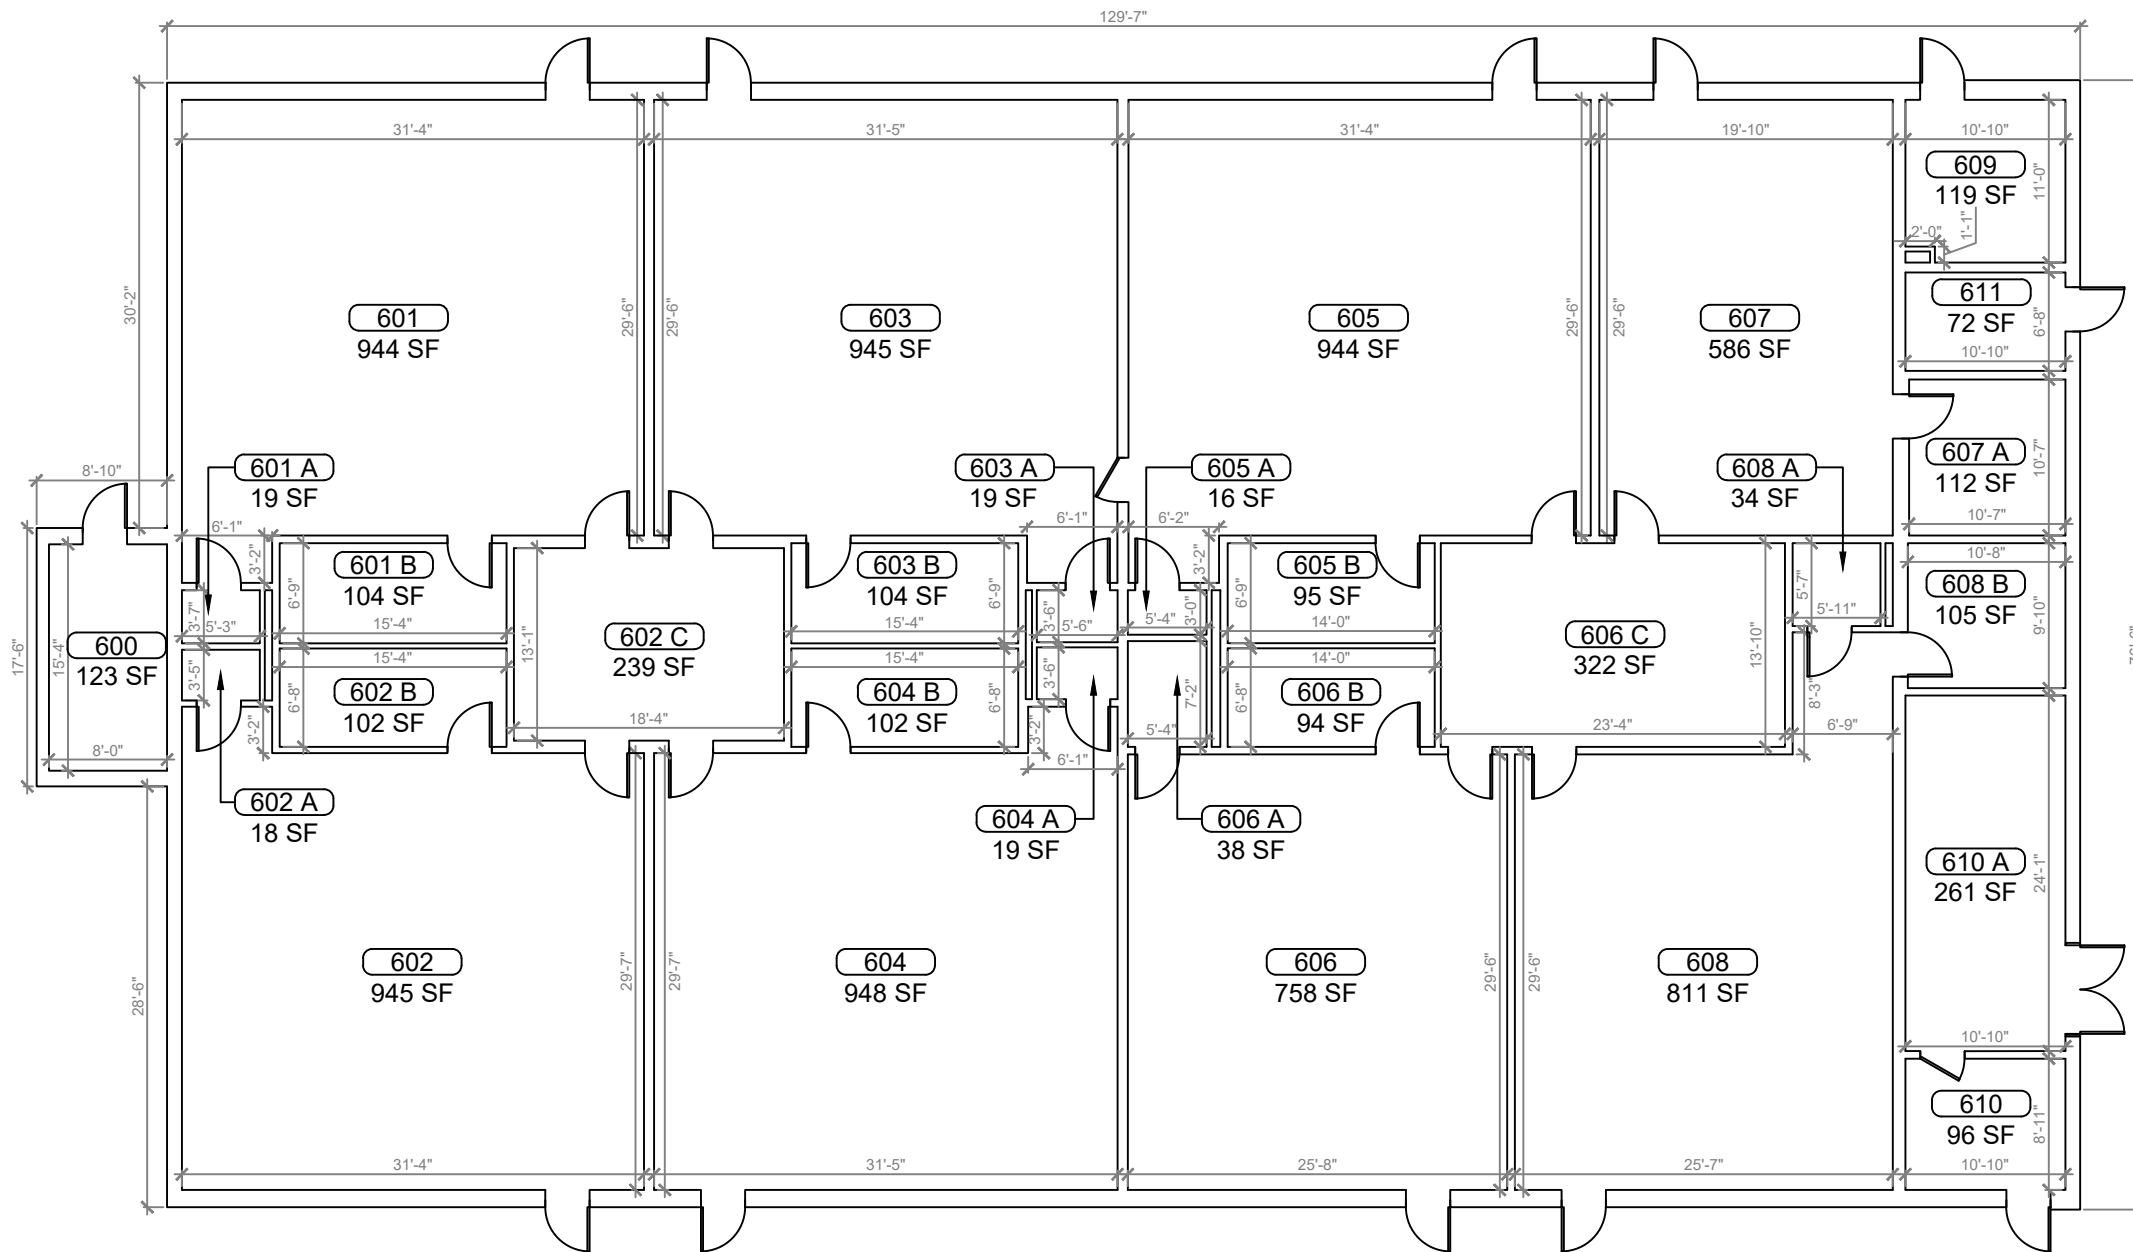

1 **BUILDING 06 FLOOR PLAN**
 B-06 SCALE: 3/16"=1'-0"

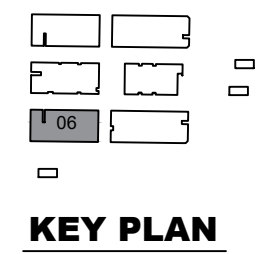

REV	DATE	DESCRIPTION
A	02/24/21	PRELIMINARY FISH PLAN
B		
0		
1		
2		
3		
4		
5		
6		

ARCHIS PROJECT NO.:	
DRAWN BY:	CHECKED BY:
YP	SH



158 Terra Mango Loop, Suite B,
 Orlando, FL 32835
 Main: (407) 293-4168

PREPARED BY:



350 E. Crown Point Road, Suite 1100
 Winter Garden, FL 34787
 Main: 888.324.2557
 Direct: 407.439.1594

DATE

, PE

FL PROFESSIONAL ENGINEER LIC. #

**Spring Creek
 Charter School
 (FISH PLAN)**

44440 Spring Creek
 Rd, Paisley, FL 32767


SHEET DESCRIPTION

BUILDING 06


SHEET NUMBER

B-06


ARCHIS TECHNOLOGIES - \\server-1\H\Archis\21-038 Spring Creek Charter\From ISP\2021-02-25\896_Lake County_Fish Survey_Spring Creek Charter.dwg February 26, 2021 10:01:03 PC20

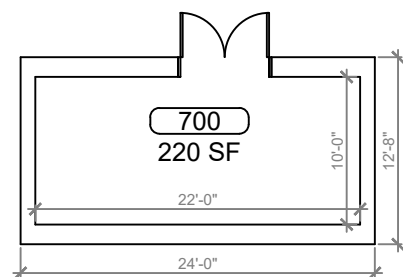


1 **BUILDING 07 FLOOR PLAN**
B-07 SCALE: 3/16"=1'-0"

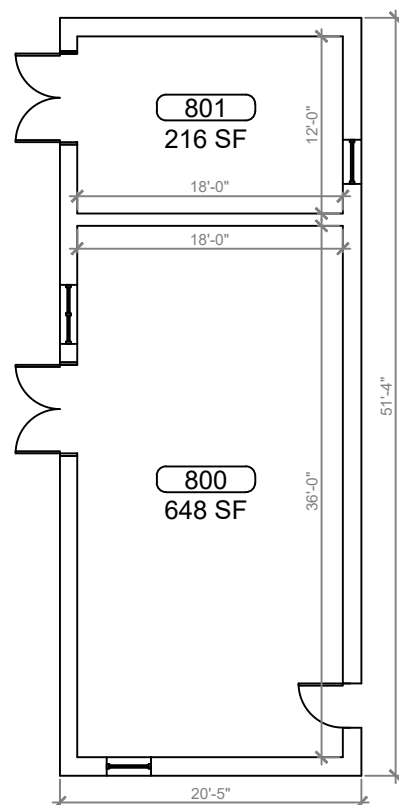

2 **BUILDING 08 FLOOR PLAN**
B-07 SCALE: 3/16"=1'-0"

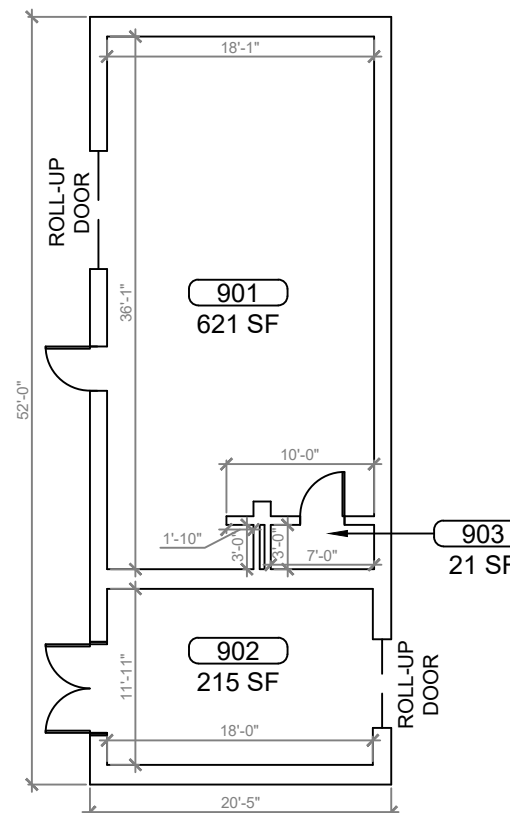

3 **BUILDING 09 FLOOR PLAN**
B-07 SCALE: 3/16"=1'-0"

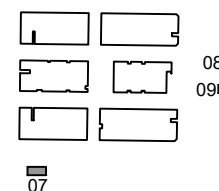


KEY PLAN



REV	DATE	DESCRIPTION
A	02/24/21	PRELIMINARY FISH PLAN
B		
0		
1		
2		
3		
4		
5		
6		

ARCHIS PROJECT NO.:	
DRAWN BY:	CHECKED BY:
YP	SH

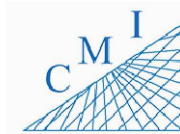

158 Terra Mango Loop, Suite B,
Orlando, FL 32835
Main: (407) 293-4168

PREPARED BY:



350 E. Crown Point Road, Suite 1100
Winter Garden, FL 34787
Main: 888.324.2557
Direct: 407.439.1594

DATE

, PE

FL PROFESSIONAL ENGINEER LIC. #

**Spring Creek
Charter School
(FISH PLAN)**

44440 Spring Creek
Rd, Paisley, FL 32767

SHEET DESCRIPTION

**BUILDING 07,
08 & 09**

SHEET NUMBER

B-07